



END ELEVATION
SCALE 1/4"=1'-0"

REVISIONS

Indian Health Service

TULUKSAK, ALASKA


PROJECT NO. AN-81-220

TOTAL SHEETS 1

DATE: FEBRUARY 1981	DATE:
---------------------	-------

ENVIRONMENTAL HEALTH BOARD
ALASKA AREA NATIVE HEALTH SERVICES
INTERMEDIATE ALASKA

THE UNIVERSITY OF CHICAGO PRESS

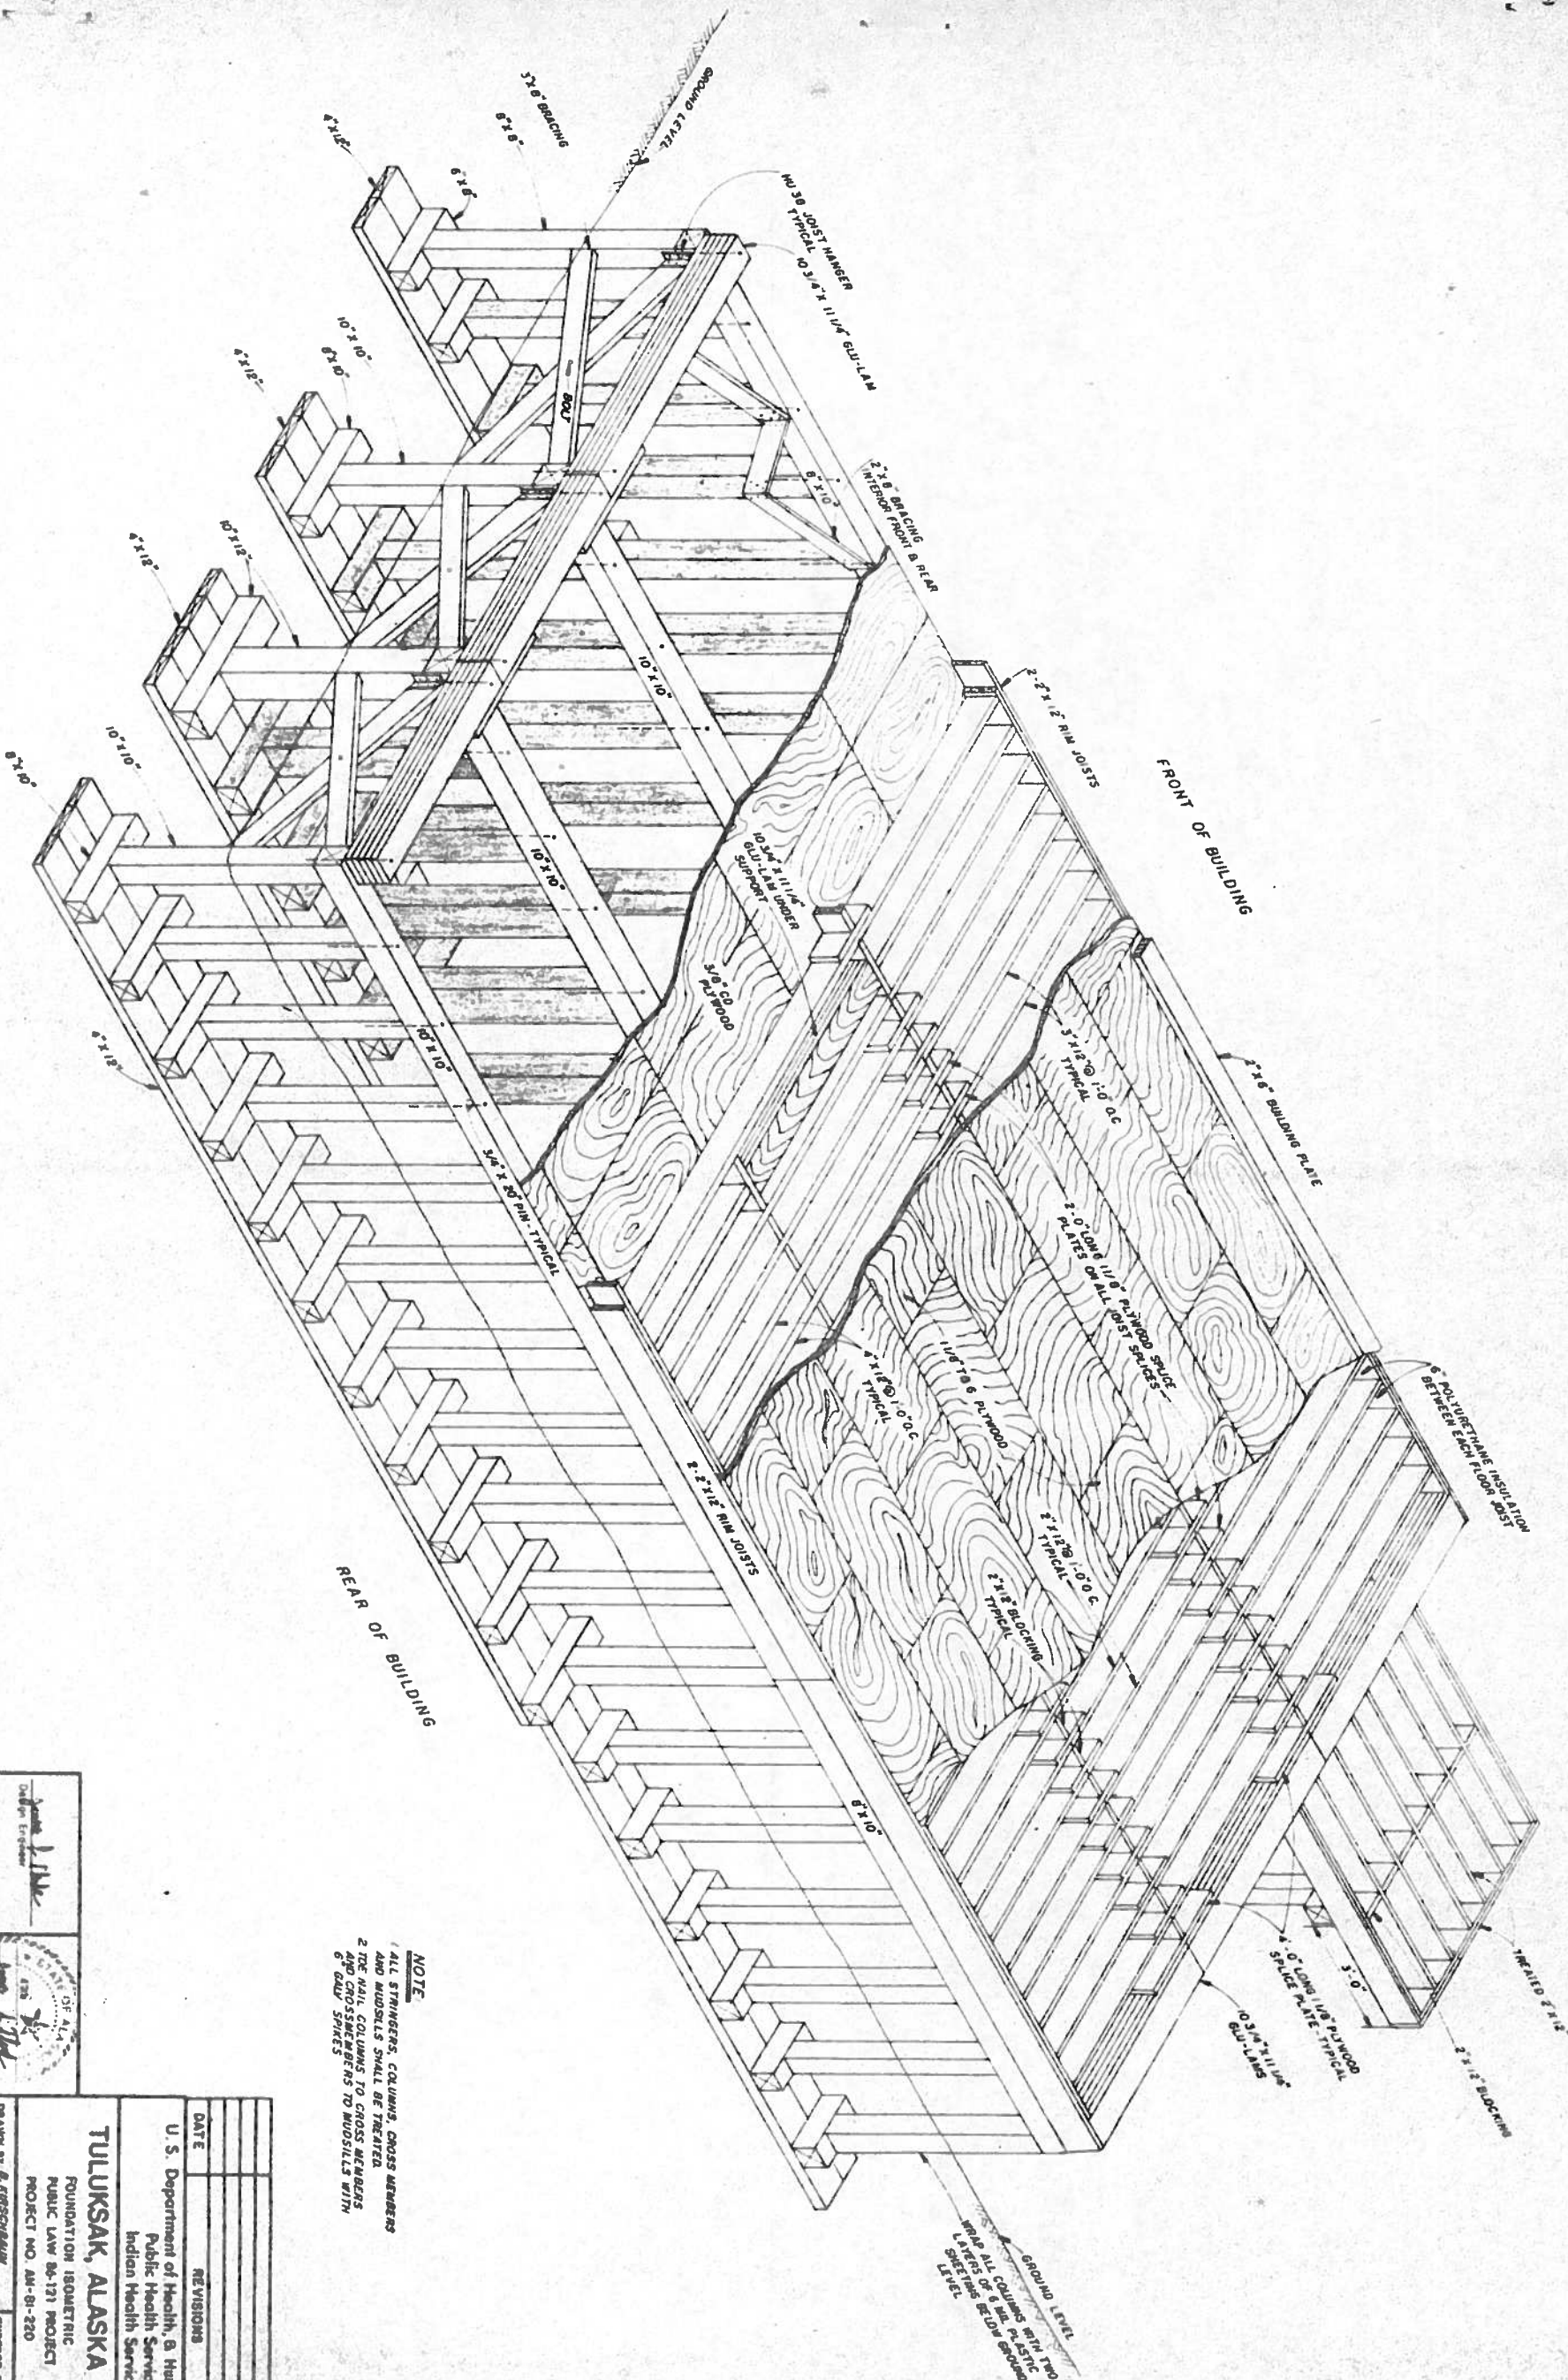

NOTE
1 ALL STRINGERS, COLUMNS, CROSS MEMBERS AND MUDSILLS SHALL BE TREATED
2 THE NAIL COLUMNS TO CROSS MEMBERS AND CROSS MEMBERS TO MUDSILLS WITH 8 DAW SPIKES

Drawn by: *[Signature]*

Checked by: *[Signature]*

Reviewed by: *[Signature]*

Approved: *[Signature]*

DATE: 1/25/61

PROJECT NO. 64-171

PROJECT NO. 64-171

DATE: 1/25/61

PROJECT NO. 64-171

PROJECT NO. 64-171

DATE	REVISIONS	INITIALS

TULUKSAK, ALASKA

FOUNDATION ISOMETRIC

PUBLIC LAW 86-171 PROJECT

PROJECT NO. 64-171

PROJECT NO. 64-171

SHEET NO. 6

OF 30

TOTAL SHEETS

DATE: 1/25/61

PROJECT NO. 64-171


PROJECT NO. 64-171

SAFARIAN FACILITIES CONSTRUCTION BRANCH


ENVIRONMENTAL HEALTH BRANCH

ALASKA AREA WATER RESOURCES DIVISION


ANCHORAGE, ALASKA

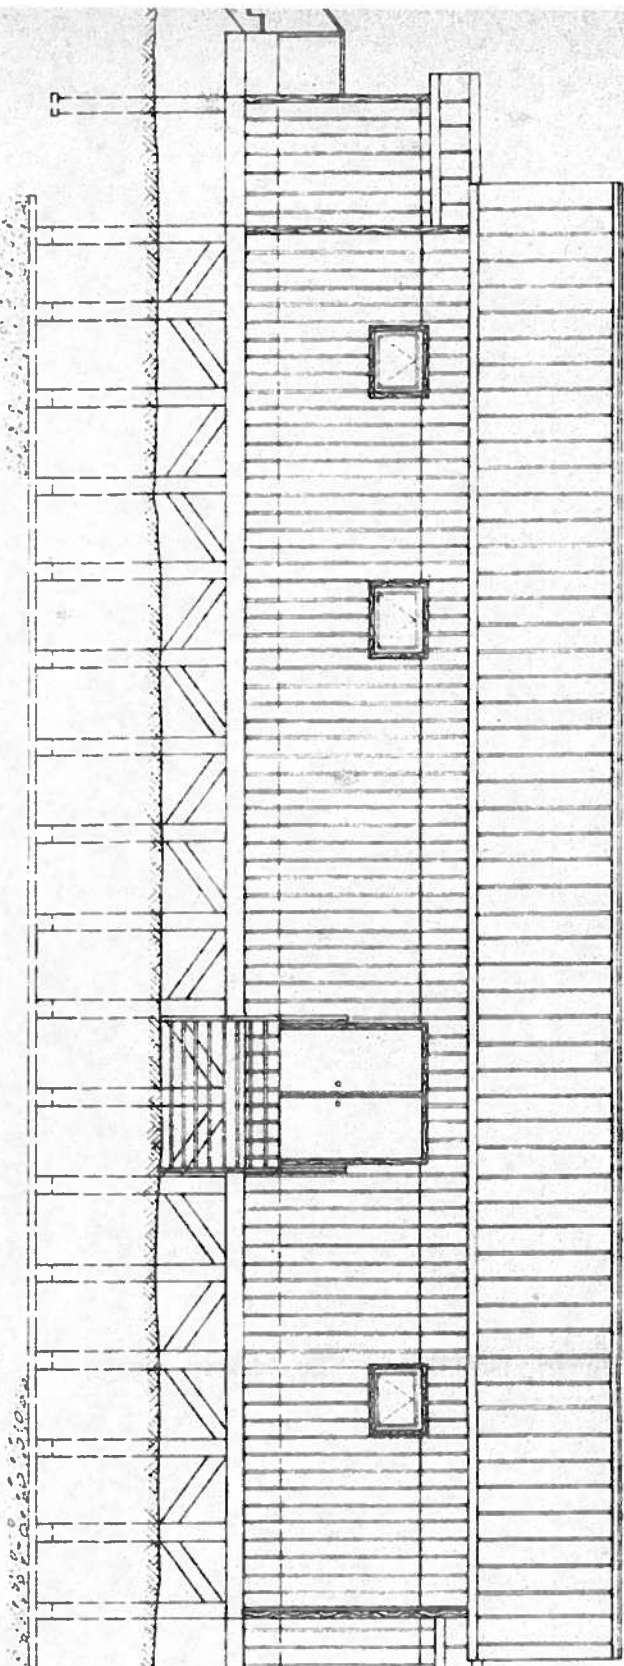

FRONT ELEVATION
SCALE 1/4"=1'-0"

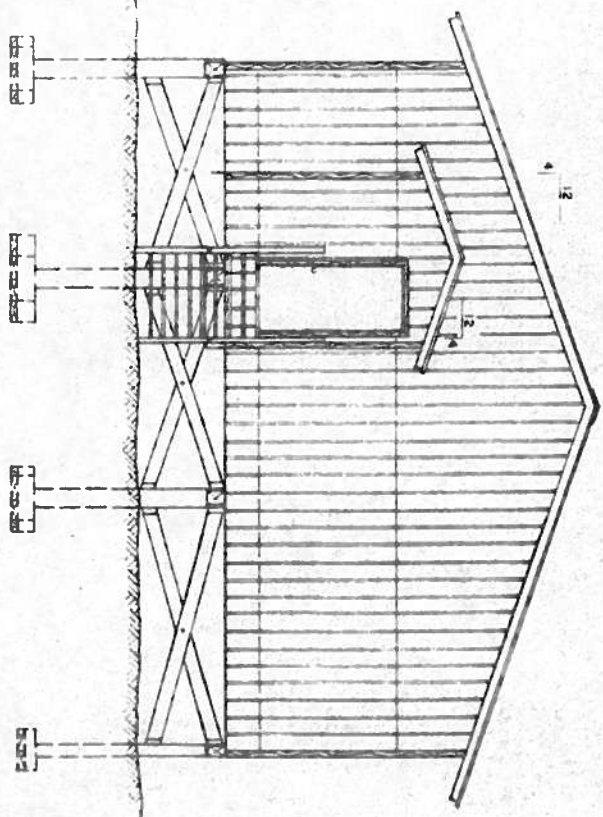

RIGHT END ELEVATION
SCALE 1/4"=1'-0"

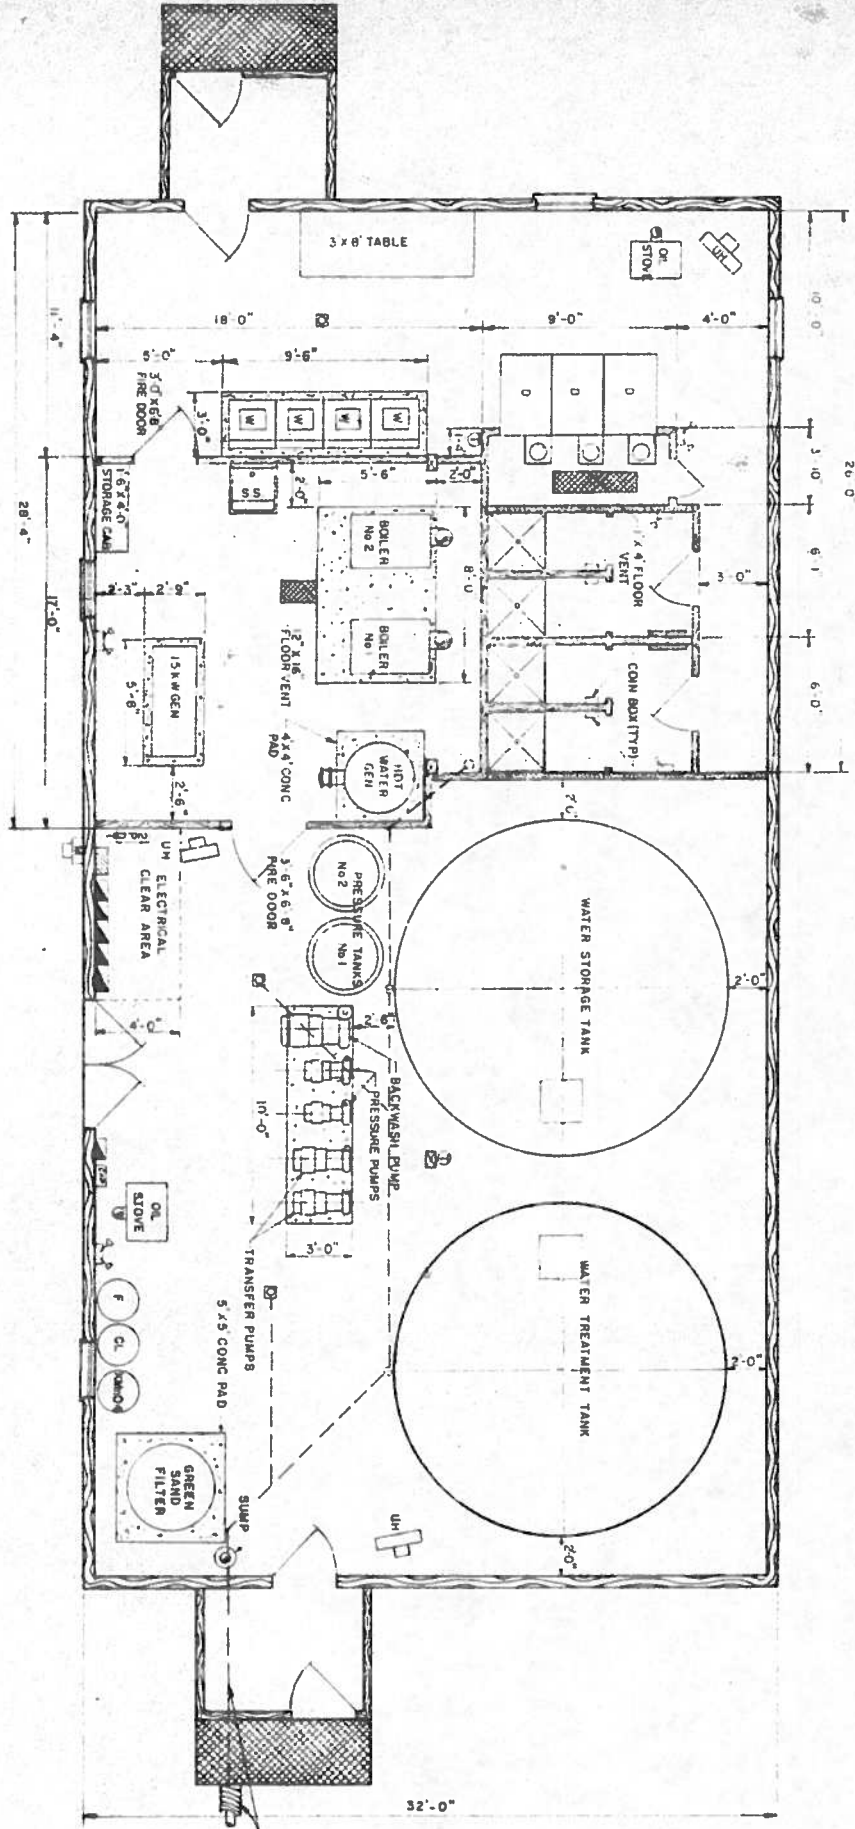

FLOOR PLAN
SCALE 1/4"=1'-0"

- NOTES
1. BOILER ROOM 1 LAYER OF 1/2" SHEET ROCK 1 LAYER OF 5/8" EXTERIOR GYPSUM BOARD W/SHAP ON CORNERS & INTERIOR TRIM (BUFF) STYLE 704
 2. MARLITE SHOWER ROOM
 3. MARLITE BACK OF WASHERS AND AROUND DRYERS, 5/8" EXTERIOR GYPSUM BOARD W/TRIM REMAINING 3 WALLS
 4. TREATMENT ROOM 1 LAYER 5/8" EXTERIOR GYPSUM BOARD W/TRIM
 5. 4" SECTION OF BASEBOARD HEATER FOR FUEL OIL PREHEATER
 6. DRIP PANS FOR ALL PUMPS, BOILERS & STOVES

Design Engineer
James J. Black

Architect
James J. Black

Contractor
James J. Black


U.S. DEPT. OF HEALTH, EDUCATION & WELFARE
ALASKA DEPARTMENT OF HEALTH, EDUCATION & WELFARE
ANCHORAGE, ALASKA

U.S. DEPT. OF HEALTH, EDUCATION & WELFARE
ALASKA DEPARTMENT OF HEALTH, EDUCATION & WELFARE
ANCHORAGE, ALASKA

DATE	REVISIONS	INITIALS

U. S. Department of Health, Education & Welfare Services Public Health Service Indian Health Service	
TULUKSAK, ALASKA	
WATER TREATMENT PLANT	
FLOOR PLAN AND ELEVATIONS	
PUBLIC LAW 84-121 PROJECT	
PROJECT NO. AM-81-220	
DRAWN BY: J. J. BLACK	CHECKED BY: J. J. BLACK
DATE: FEBRUARY 1981	DATE: FEBRUARY 1981
SANITATION FACTORY'S CONSTRUCTION BRANCH	
ENVIRONMENTAL HEALTH BRANCH	
ALASKA AREA NATIVE HEALTH SERVICE	
ANCHORAGE, ALASKA	

SHEET NO.	12
OF	30
TOTAL SHEETS	

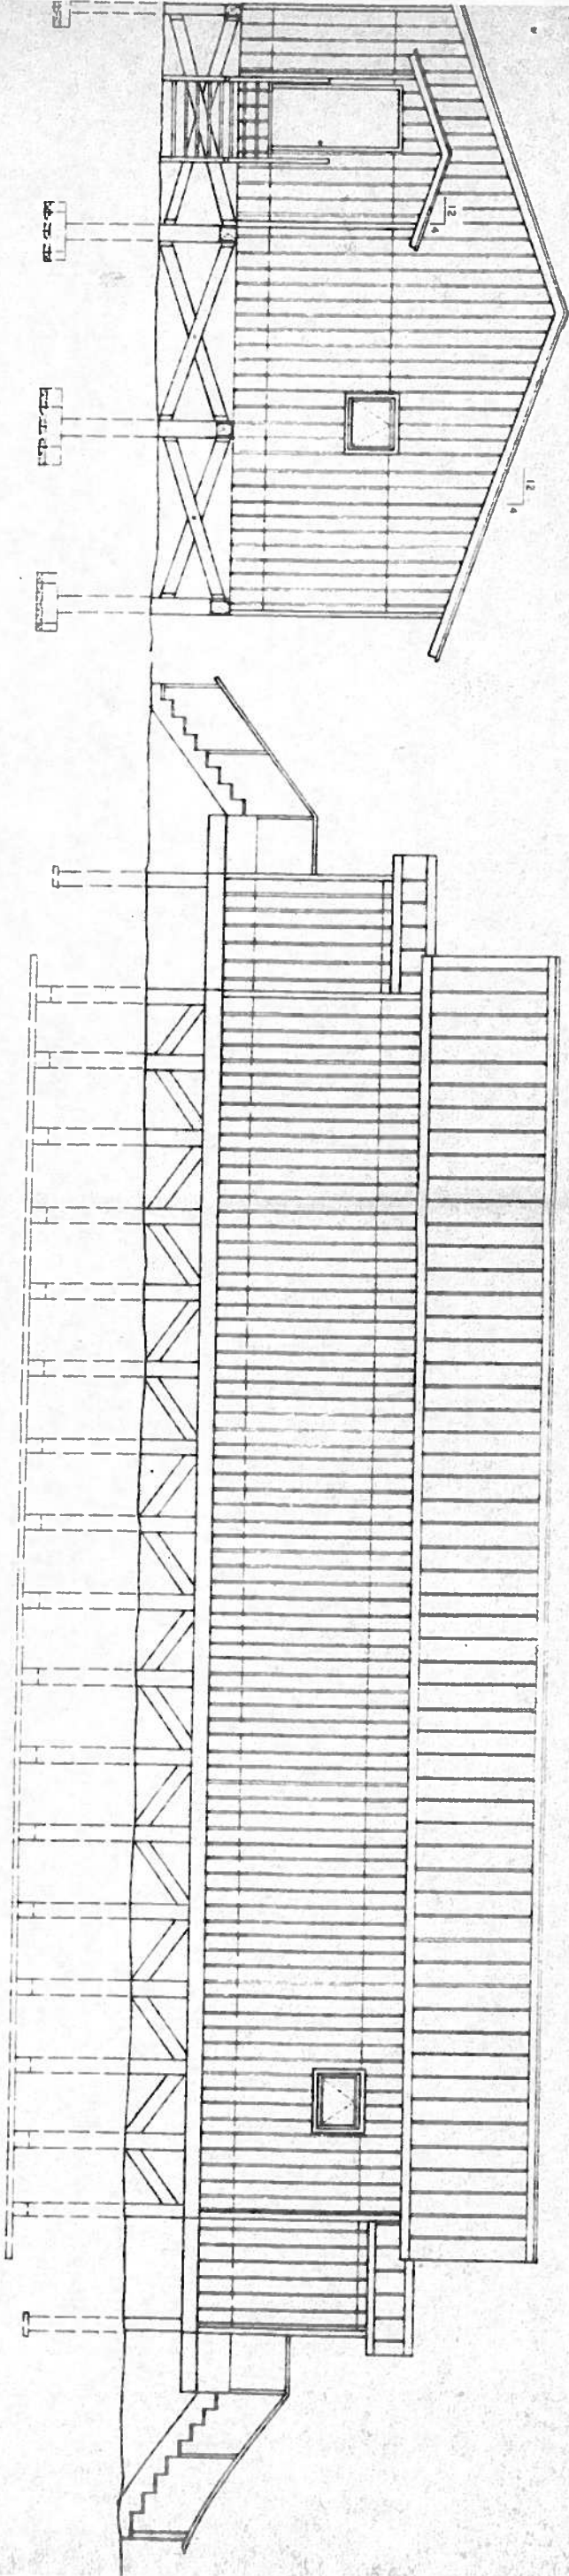

LEFT END ELEVATION
SCALE: 1/4" = 1'-0"

REAR ELEVATION
SCALE: 1/4" = 1'-0"


Design Engineer
John P. Miller

Businesses Division
U.S. Forest Service

U.S. Forest Service
Alaska Division

U.S. Forest Service
Alaska Division


DATE	REVISIONS	INITIALS
U.S. Department of Health & Human Services Public Health Service Indian Health Service		
TULUKSAK, ALASKA		
WATER TREATMENT PLANT		
PUBLIC LAW 84-121 PROJECT		
PROJECT NO. AN-0-220		
TOTAL SHEETS: 30		
DRAWN BY: A. BRIDGEMAN		
DATE: FEBRUARY, 1989		
CHECKED BY:		
DATE:		
SANITATION FACILITIES CONSTRUCTION BRANCH		
ENVIRONMENTAL HEALTH BRANCH		
ALASKA AREA WATER SUPPLY SERVICE		
ANCHORAGE, ALASKA		

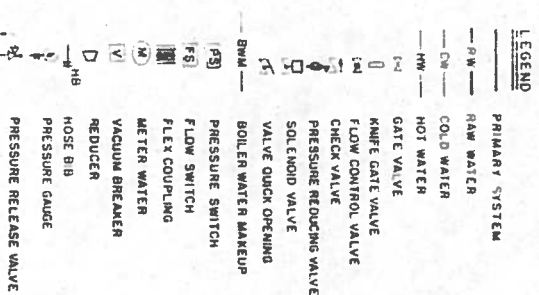

- 1 GREEN - RAW WATER
- 2 BLUE - POTABLE WATER
- 3 BLACK - HEATING
- 4 RED - FIRE
- 5 BROWN - SEWAGE
- 6 GRAY - COMPRESS AIR
- 7 ORANGE - FUEL
- 8 2 TYPE OF PAINT SHALL BE USED CARBOLAC OR EQUAL
- 9 DIRECTION OF FLOW WILL BE INDICATED BY ARROWS AND NAME
- 10 PLATED FOR MATERIAL BEING CARRIED
- 11 ALL PIPING TO BE COPPER UNLESS OTHERWISE NOTED

WATER POINT

[illegible]

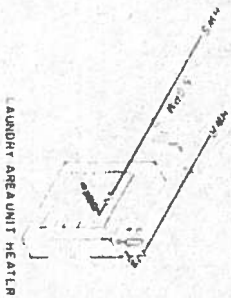

ITEM NO.	DESCRIPTION	QTY	UNIT	PRICE	TOTAL
1-1	HEATING WATER SERVICE	1	FT	1.50	1.50
1-2	HEATING WATER RETURN	1	FT	1.50	1.50
1-3	AUTOMATIC TEMP CONTROL VALVE	1	EA	12.00	12.00
1-4	GATE VALVE	1	EA	12.00	12.00
1-5	SOLENOID VALVE	1	EA	12.00	12.00
1-6	ZONE VALVE	1	EA	12.00	12.00
1-7	AUTOMATIC AIR RELEASE	1	EA	12.00	12.00
1-8	THERMOWLOW BALANCE	1	EA	12.00	12.00
1-9	CIRCUIT SETTER BALANCE VALVE	1	EA	12.00	12.00
1-10	PRESSURE RELEASE VALVE	1	EA	12.00	12.00
1-11	UNION	1	EA	12.00	12.00
1-12	CHECK VALVE	1	EA	12.00	12.00
1-13	THERMOMETER	1	EA	12.00	12.00
1-14	PRESSURE REDUCING VALVE	1	EA	12.00	12.00
1-15	AQUASAT	1	EA	12.00	12.00
1-16	STRAINER	1	EA	12.00	12.00

[illegible]

**U. S. Department of Health, & Human Services
Public Health Service
Indian Health Service**


TULUKSAK, ALASKA

HYDRAULIC SYSTEM
PUBLIC LAW 86-121 PROJECT
PROJECT NO. AN-80-220


DRAWN BY: JAG DATE: APR 01	CHECKED BY: DATE:
-------------------------------	----------------------

SANITATION FACILITIES CONSTRUCTION BRANCH
ENVIRONMENTAL HEALTH BRANCH
ALASKA AREA NATIVE HEALTH SERVICE
ANCHORAGE, ALASKA


CLUB DE LA LECTURA

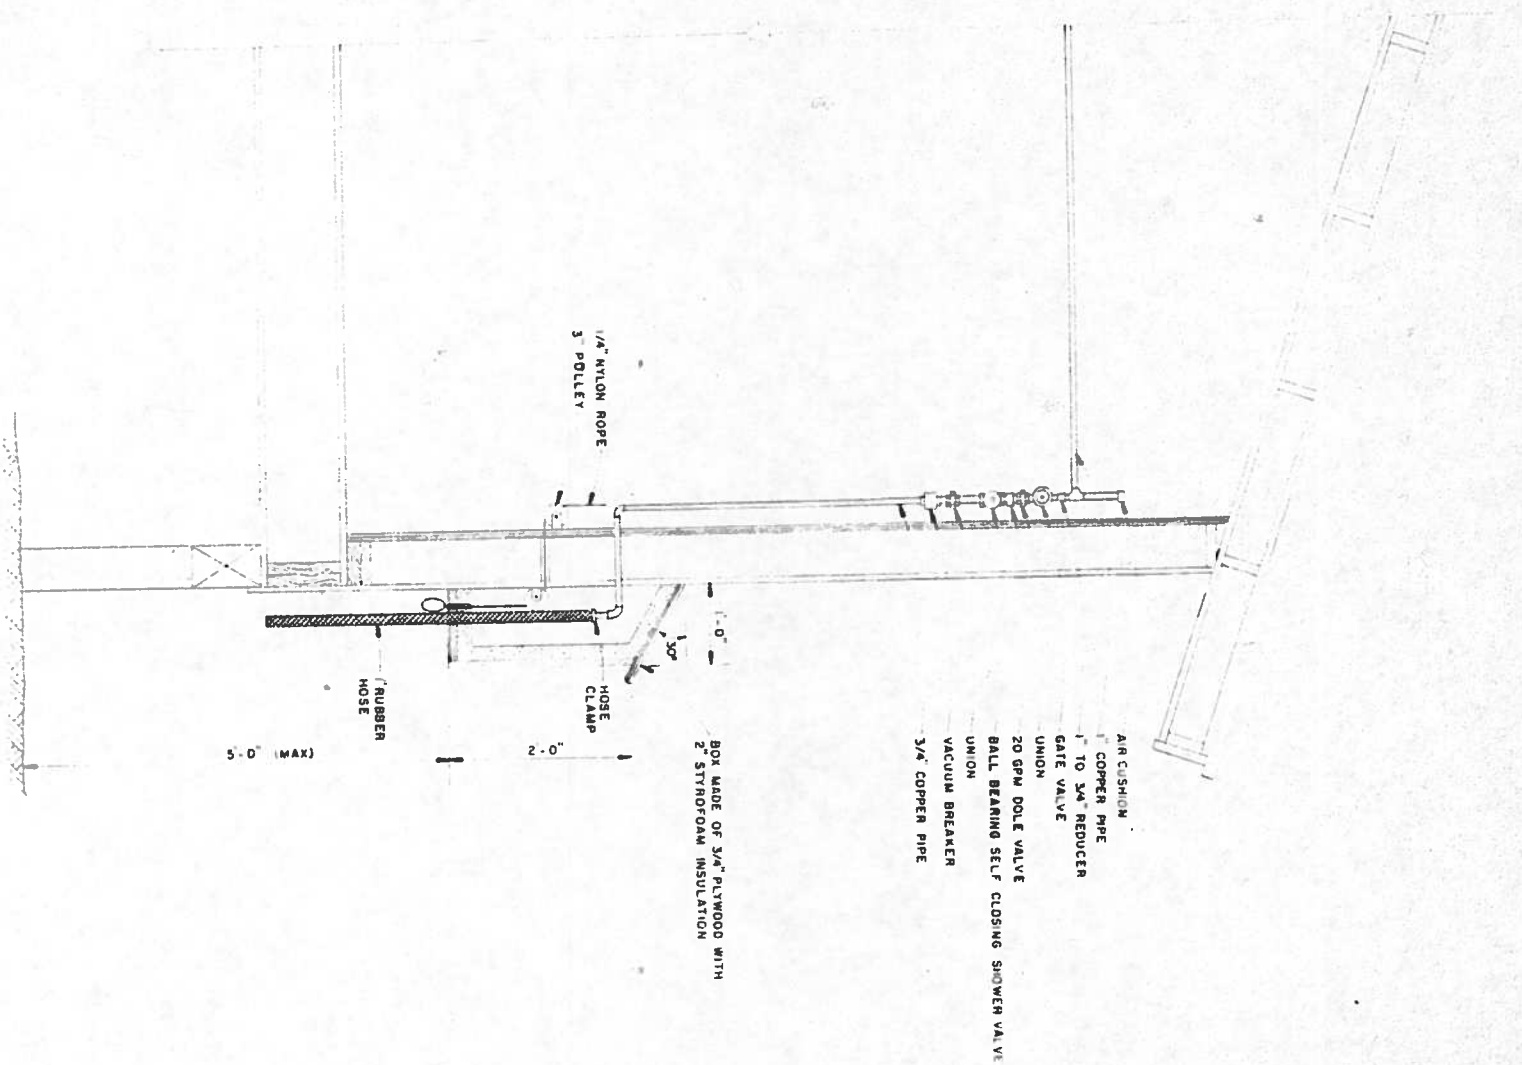


WATER POINT ASSEMBLY SECTION
SCALE 1"=10'

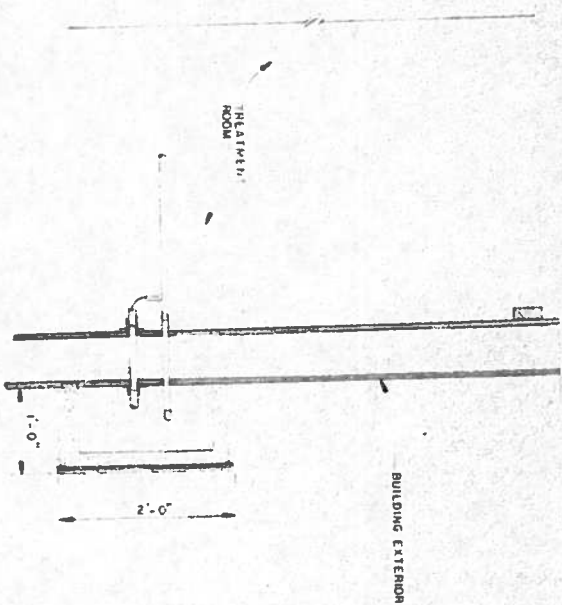

WATER POINT BOX AND PIPING PLAN

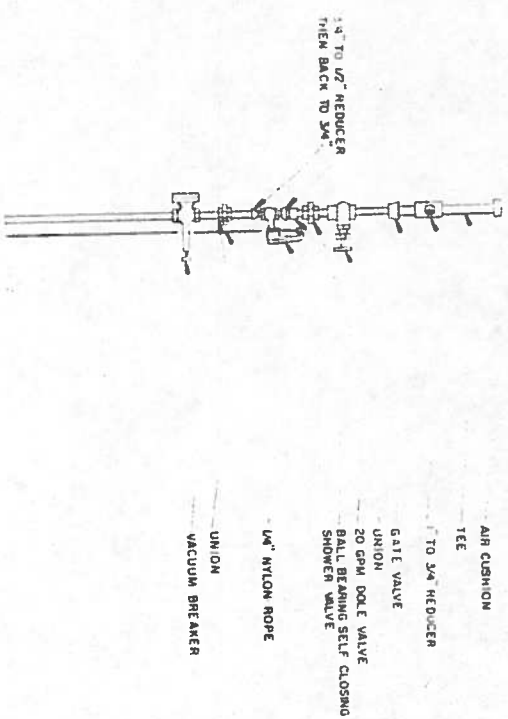


FRONT VIEW
NTS

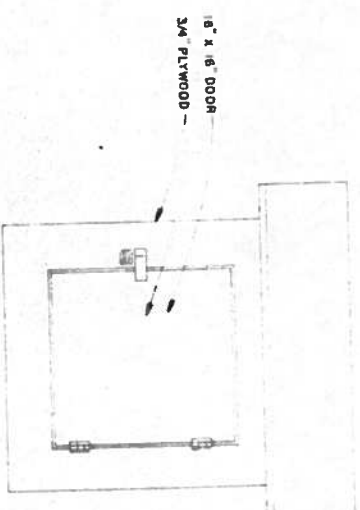

BOX ELEVATION
NTS


WATER POINT DETAILS PUBLIC LAW 94-121 PROJECT PROJECT NO. AN-81-22	TOTAL SHEETS 30
SAUTATION FACILITIES CONSTRUCTION BRANCH ENVIRONMENTAL HEALTH SECTION AIR QUALITY DIVISION AIR QUALITY BRANCH	
DRAWN BY: B. HINCHESON DATE: MAR 1981	CHECKED BY: _____ DATE: _____
Design Engineer: <i>James I. Black</i> Modification: <i>None</i> Drawn: <i>None</i>	

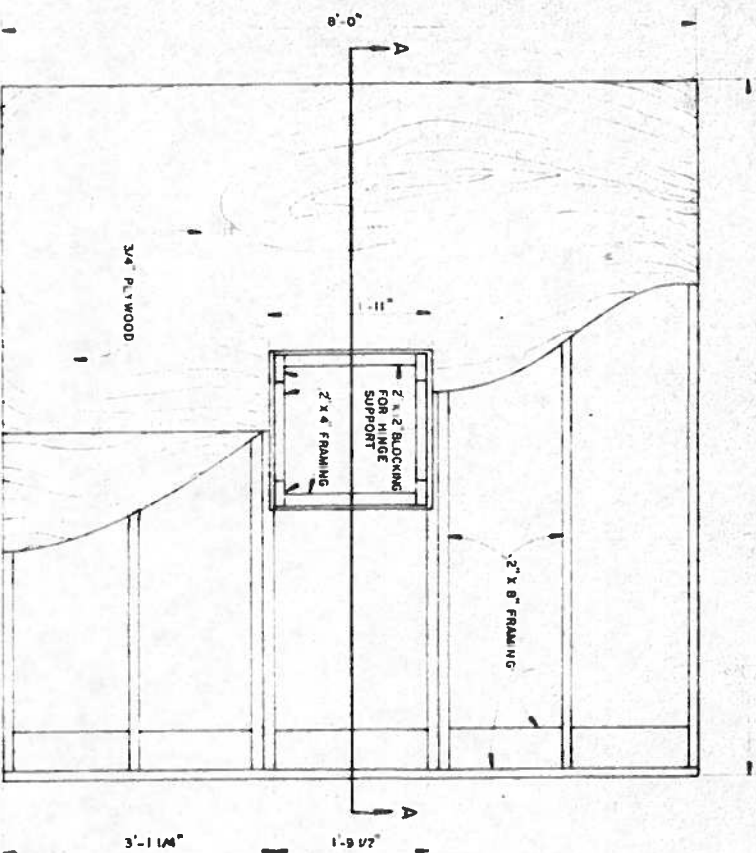

PLAN VIEW
SCALE: 1"=1'-0"

1/4" x 3" BOLTS WITH
WASHERS AND NUTS
8 EACH REQUIRED
PER LID


3'-0"

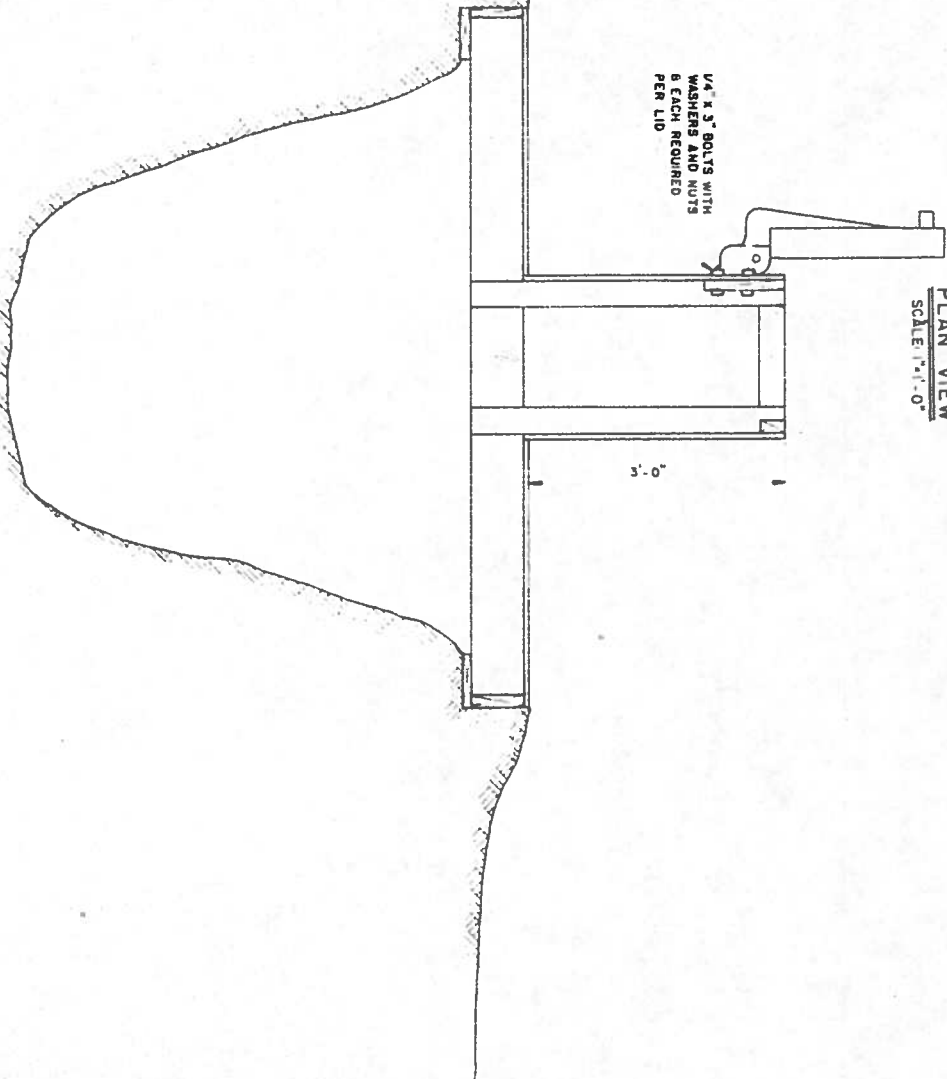


SECTION A-A
SCALE: 1"=1'-0"

NOTES

1. ALL LUMBER AND PLYWOOD SHALL BE TREATED.
2. SEVEN SEWAGE BUNKERS ARE REQUIRED. THEY ARE TO BE LOCATED THROUGHOUT THE VILLAGE.
3. NAIL PLYWOOD ON WITH 8d GALVANIZED NAILS AT 6" O.C.
4. USE 18d GALVANIZED NAILS FOR ALL 2"x4" FRAMING CONNECTIONS.

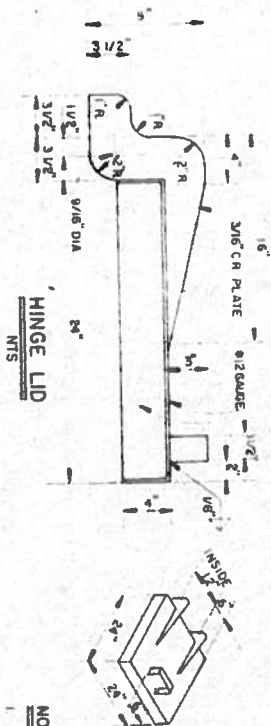

HINGE LID
NTS

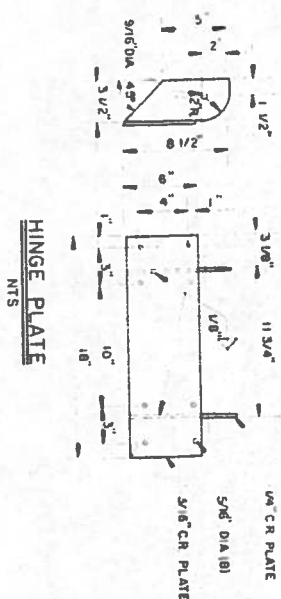


HINGE PLATE
NTS

NOTES

1. PRIME COAT WITH RED OXIDE ON EQUAL.
2. PROVIDE 1/2" x 1" CLEVIS PINS WITH WASHERS AND COTTER PINS - 2 EACH REQUIRED PER LID.
3. PROVIDE 1/4" x 3" GALVANIZED BOLTS WITH WASHERS AND NUTS - 8 EACH REQUIRED PER HINGE.

Design Engineer <i>James L. Allen</i>	
Working Drawings Revised	
Working Drawings Tear-off	


U. S. Department of Health, & Human Services Public Health Service Indian Health Service	
TULUKSAK, ALASKA SEWAGE DISPOSAL BUNKER PUBLIC LAW 86-121 PROJECT PROJECT NO. AN-81-220	
DRAWN BY: B. KINCHEN DATE: MAY, 1981	CHECKED BY: _____ DATE: _____
SANITATION FACILITIES CONSTRUCTION BRANCH ENVIRONMENTAL HEALTH BRANCH ALASKA, ANCHORAGE, ALASKA	
SHEET NO. 17 OF 30 TOTAL SHEETS	

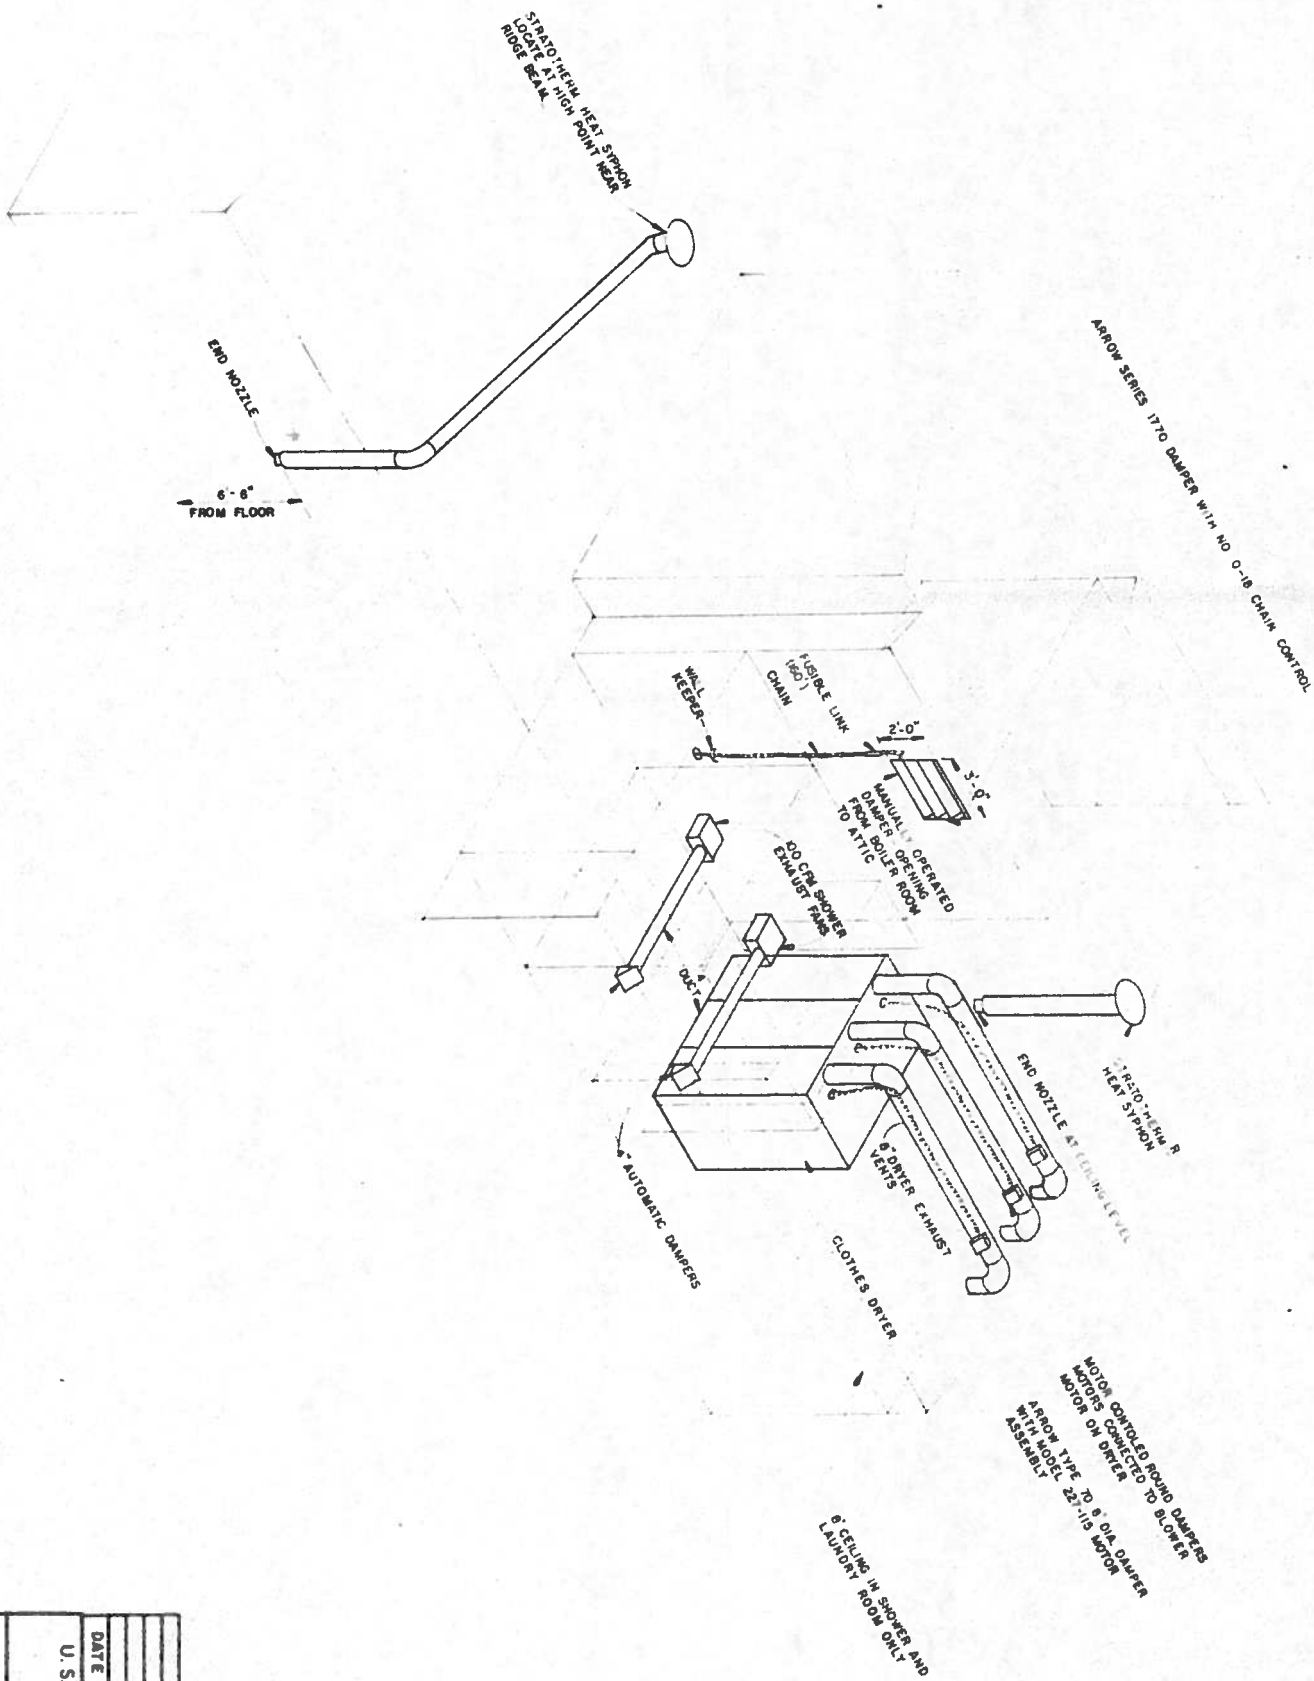


Design Engineer <i>[Signature]</i>	<i>[Stamp]</i>
1/2" Scale 1/2" Scale	

DATE	REVISIONS	INITIALS


U. S. Department of Health, & Human Services Public Health Service Indian Health Service	
TULUKSAK, ALASKA	
HEATING & VENTILATION DUCT SYSTEMS PUBLIC LAW 86-121 PROJECT PROJECT NO. AM-81-220	
DRAWN BY: B. HIRSCHMAN DATE: 4/17/81	CHECKED BY: DATE:
SANITATION PARTIES CONSTRUCTION BRANCH ENVIRONMENTAL HEALTH BRANCH ALASKA ANCHORAGE, ALASKA	
SHEET NO. 18 OF 30 TOTAL SHEETS	

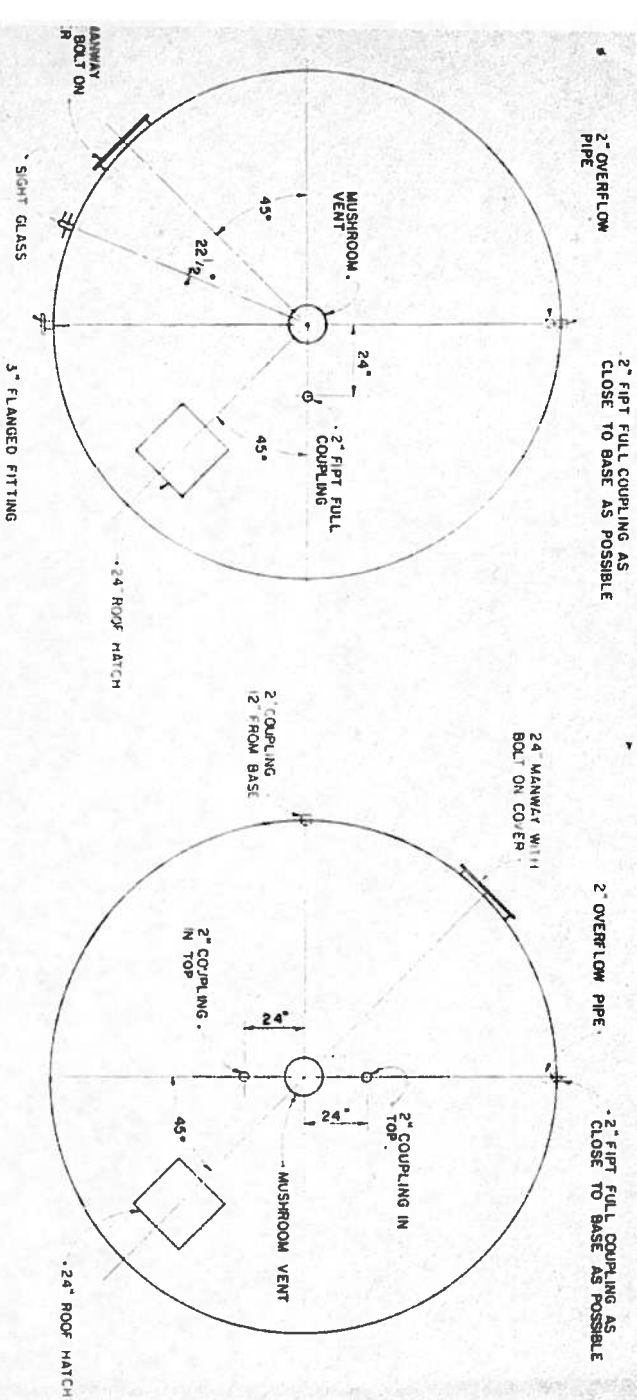


PLAN VIEW
NOT TO SCALE

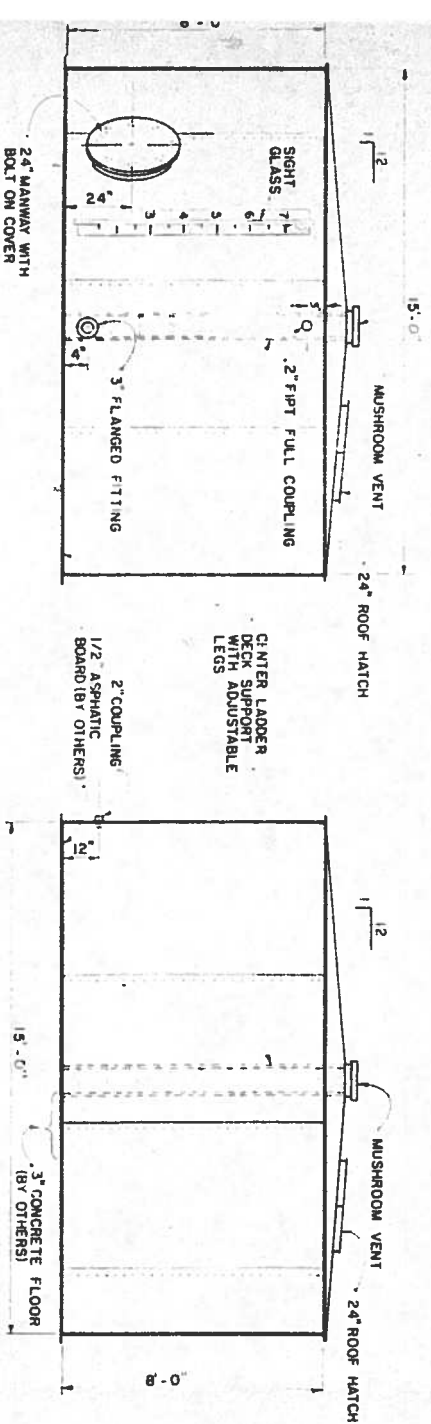


BOLTED STEEL TANKS

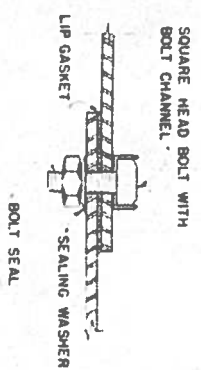


VERTICAL SEAM DETAIL

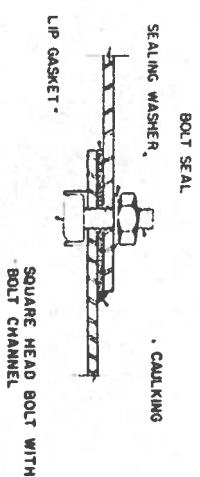


BOTTOM SEAM DETAIL

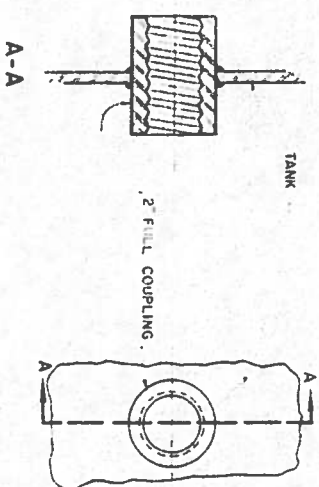


TYPICAL FULL COUPLING DETAIL
NOT TO SCALE

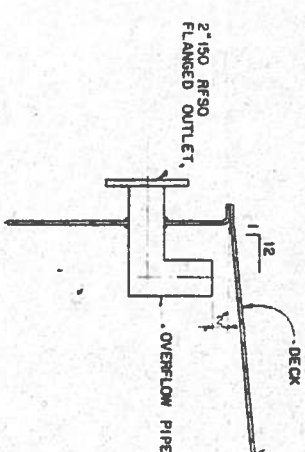

OVERFLOW DETAIL
— NOT TO SCALE —

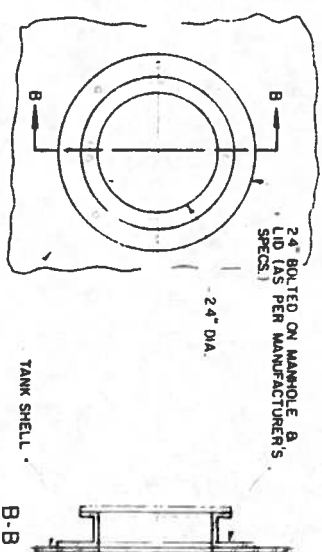

MANWAY DETAIL

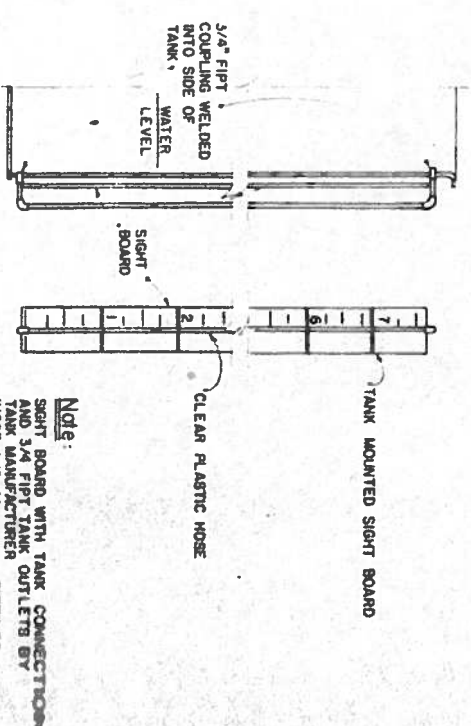

SIGHT GLASS DETAIL

[illegible]


**U. S. Department of Health, Education & Welfare
Public Health Service
Indian Health Service**

TULUKSAK ALASKA
WATER TREATMENT PLANT
WATER TANK DETAIL
PUBLIC LAW 86-121 PROJECT
PROJECT NO. AM-80-220
TOTAL SHEETS: 19
OF 30
SHEET NO.


DRAWN BY DATE	JOHN HARVEY FEB. 79	CHECKED BY DATE
------------------	------------------------	--------------------

"N"	"A"	"B"
6'-0"	4 1/2"	6"
8'-0"	6 1/2"	7"
12'-0"	9"	10 1/2"
18'-0"	15"	15"
24'-0"	25"	17"


FITTING OR PIPE DIA.	"C"
3"-4"	1/2" x 3 x 5"
6"-8"	1/2" x 3 x 5"
10"-14"	1/2" x 3 x 8"
18"-24"	1/2" x 3 x 10"

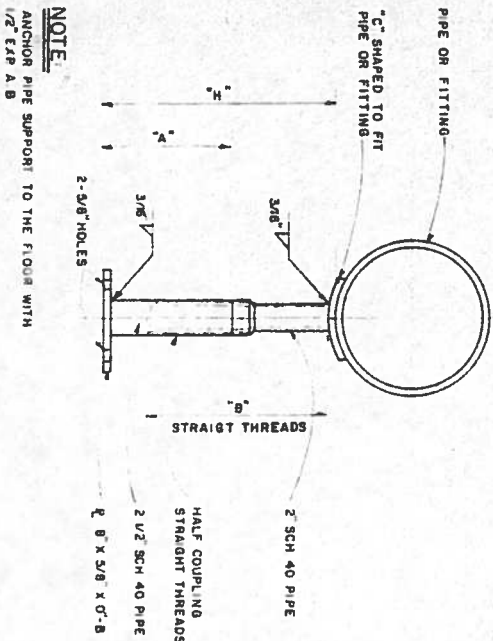


PIPE SUPPORT TYPICAL
NTS

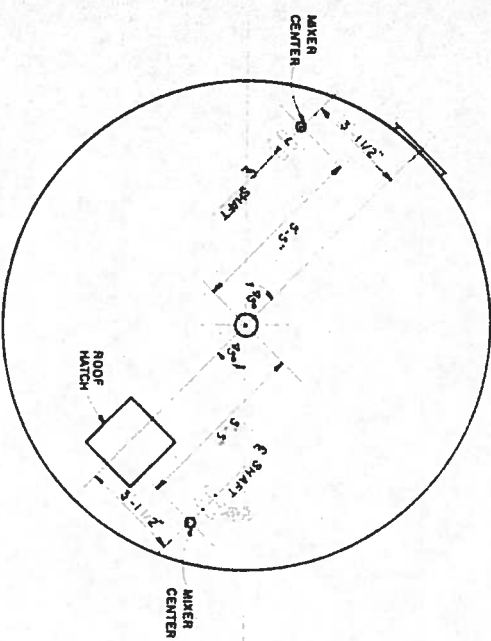


PLAN VIEW

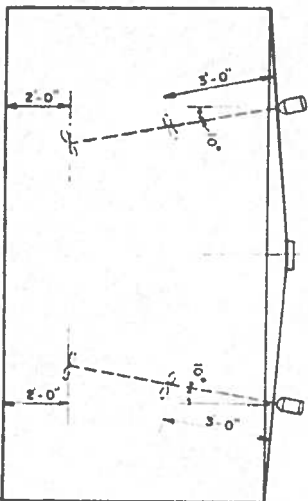

ELEVATION
SETTLING TANK MIXER SPACING
NTS

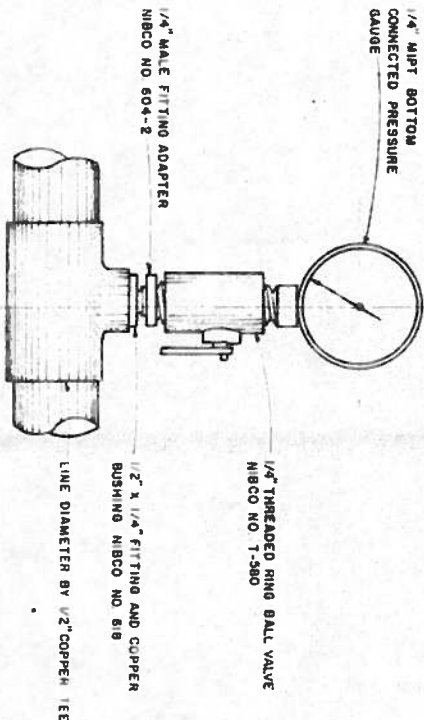



PRESSURE GAUGE INSTALLATION-TYPICAL
NTS

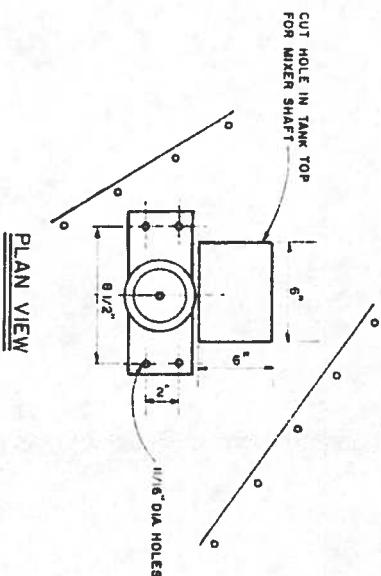

PLAN VIEW




SECTION
MIXER CUP-PLATE MOUNT
NTS

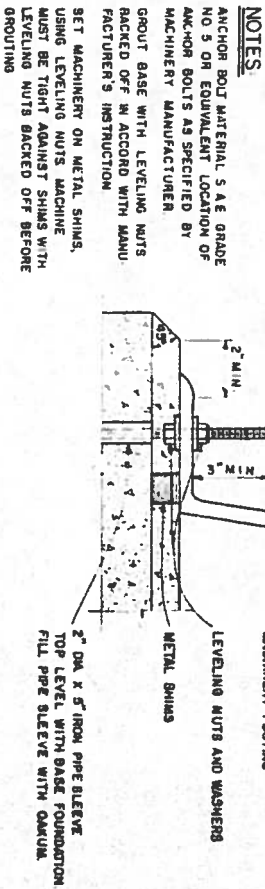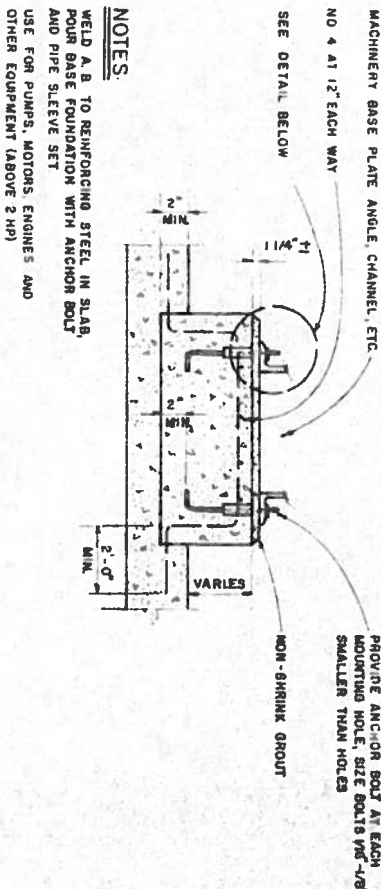


MACHINERY FOUNDATION DETAIL
NTS


DATE REVISIONS INITIALS		SHEET NO. 20 OF 30 TOTAL SHEETS	
U. S. Department of Health, Education & Welfare Public Health Service Indian Health Service			
TULUKSAK, ALASKA MECHANICAL DETAILS PUBLIC LAW 86-151 PROJECT PROJECT NO. AN-80-220		DRAWN BY B. HIRSCHMAN DATE MAY, 1979 CHECKED BY DATE	
SANITATION FACILITIES CONSTRUCTION BRANCH ENVIRONMENTAL HEALTH BRANCH ALASKA AREA NATIVE HEALTH SERVICE ANCHORAGE, ALASKA			

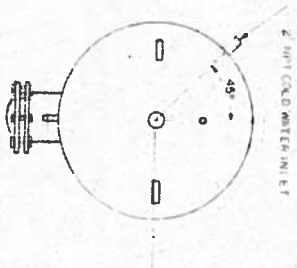

TOP VIEW

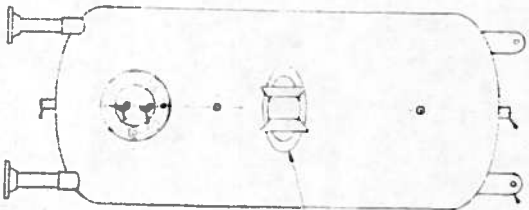

FRONT VIEW

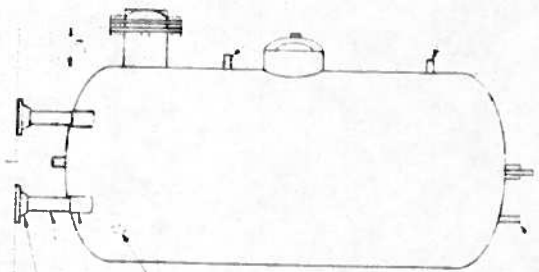

SIDE VIEW

HOT WATER GENERATOR

SCALE 3/4\"/>

- NOTES
1. 450 PSI WORKING WATER TO 125 PSI
 2. APPROXIMATE STORAGE CAPACITY 325 GALLONS
 3. 1/2\"/>
 4. 1/2\"/>
 5. 1/2\"/>
 100. 1/2\"/>

DATE	REVISIONS	INITIALS


U S Department of Health & Human Services
Public Health Service
Indian Health Service

TULUKSUK, ALASKA

HOT WATER GENERATOR
PUBLIC LAW 86-121 PROJECT
PROJECT NO AN-80-220


SANITATION PARTNERS CONSTRUCTION BRANCH
ENVIRONMENTAL HEALTH BRANCH
ALASKA
ANCHORAGE, ALASKA

Two files
John + David

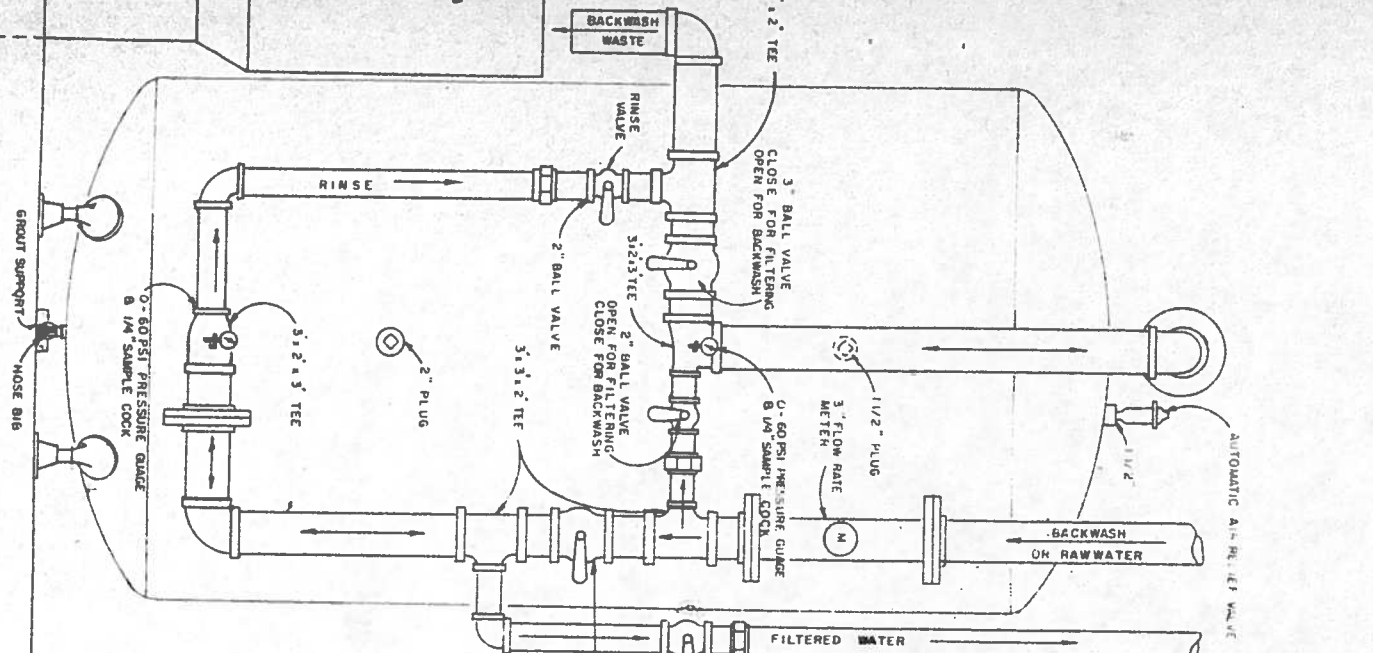

NOTE
THE TANK WAS PREVIOUSLY
ACQUIRED HOWEVER THE PLUMBING
IS REQUIRED AS SHOWN ALSO THE
FILTER MEDIA AND SUPPORT LEGS
ARE REQUIRED
THE PLUMBER SHOULD CONSIDER
THIS DRAWING WITH THE EXISTING
TANK TO DETERMINE THE
MATERIALS NEEDED.

FRONT VIEW
NTS

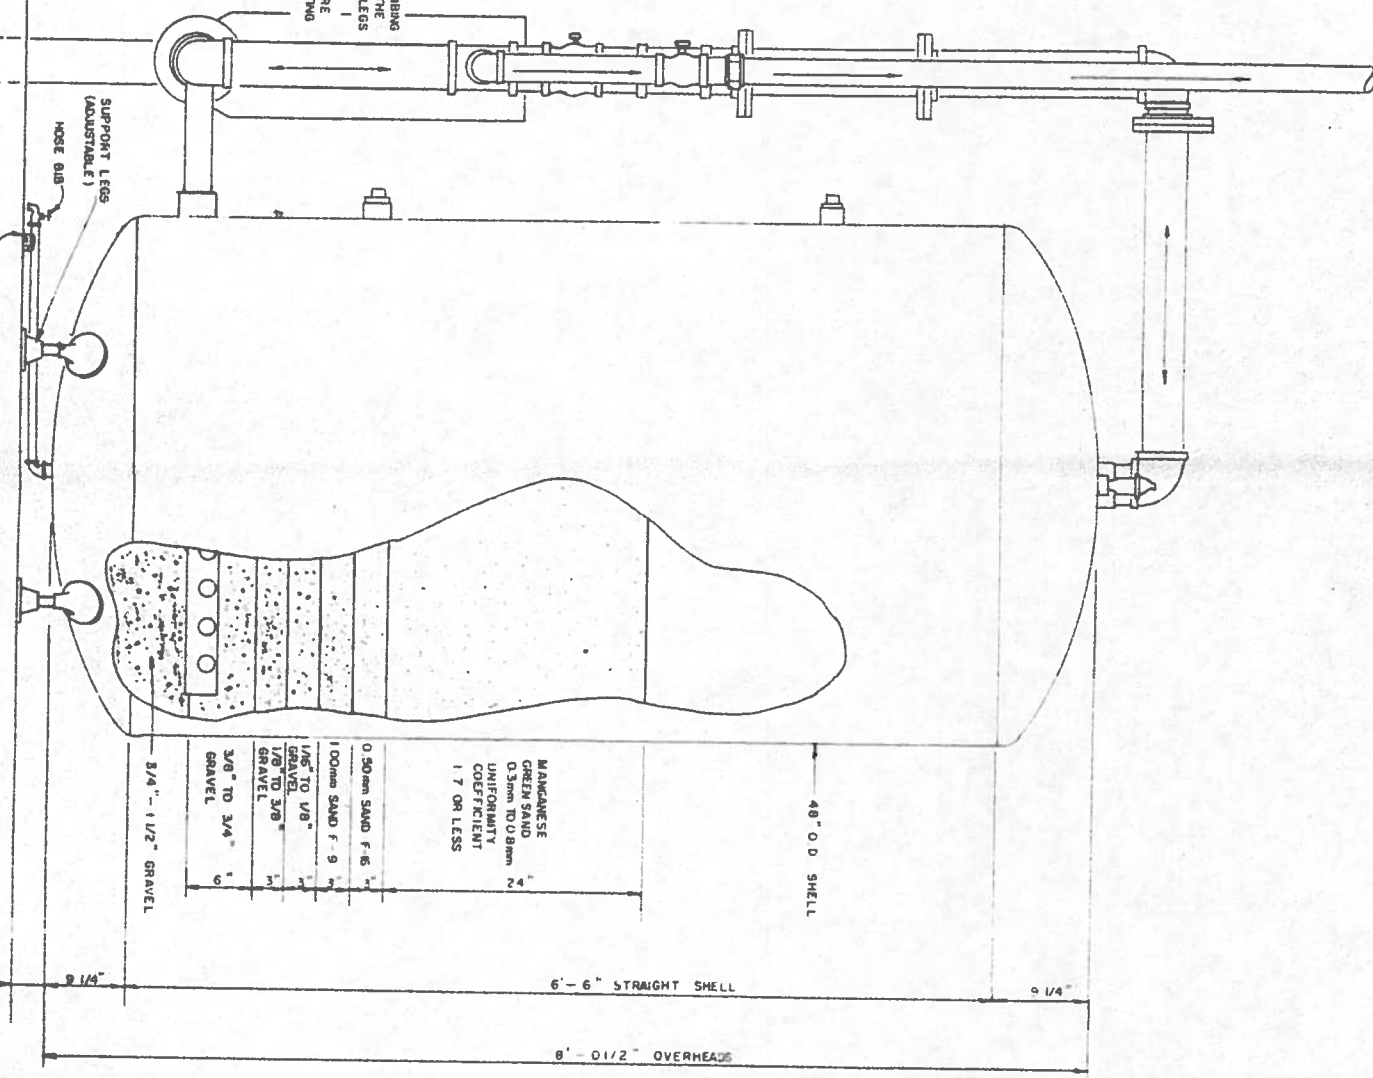

SIDE VIEW
NTS

- MANCANESE GREEN SAND D. 3mm TO 0.075mm UNIFORMITY COEFFICIENT 1.7 OR LESS
- 0.50mm SAND F-6
- 1.00mm SAND F-9
- 1/8" TO 1/4"
- 1/8" TO 3/8" GRAVEL
- 3/8" TO 3/4" GRAVEL

Design Engineer
James J. Hill


Supervisor
John J. Hill

Working Drawings


Revisions

DATE	REVISIONS	INITIALS


U. S. Department of Health & Human Services Public Health Service Indian Health Service		SHEET NO. 22 OF 30 TOTAL SHEETS
TULUKSAK, ALASKA GREEN SAND FILTER PUBLIC LAW 86-171 PROJECT PROJECT NO. AN-81-220		
DRAWN BY JPH DATE 4-24-81	CHECKED BY 	DATE
SANITATION FACILITIES CONSTRUCTION BRANCH ENVIRONMENTAL HEALTH BRANCH ALASKA AREA HEALTH SERVICE ANCHORAGE, ALASKA		

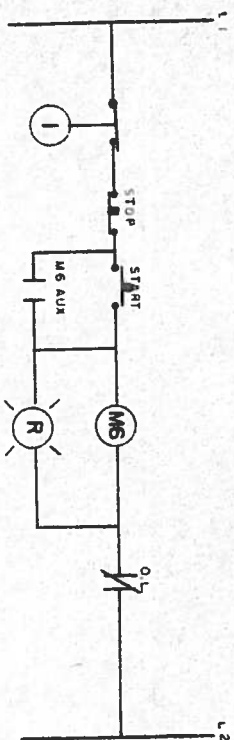


SUPPLY PUMP CONTROL

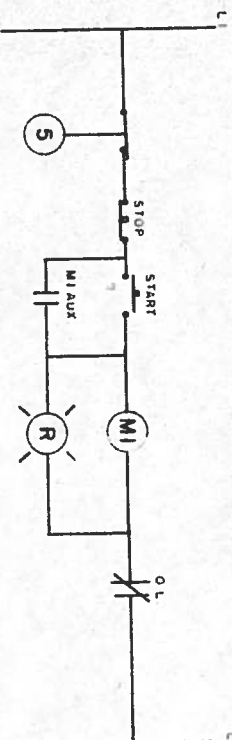


BACKWASH PUMP CONTROL

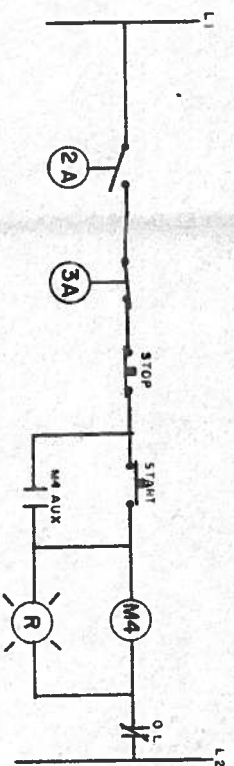


TRANSFER PUMP CONTROL (TYP) 2nd PUMP USES
"B" CONTROLS

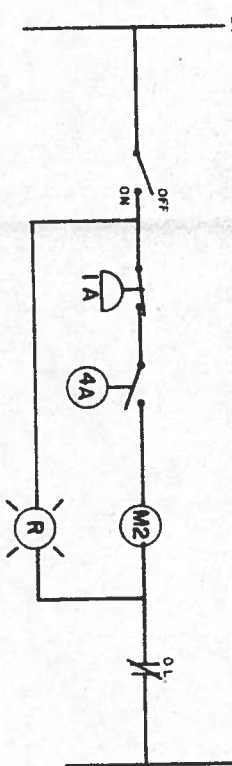


PRESSURE PUMP CONTROL (TYP) 2nd PUMP USES
"B" CONTROLS

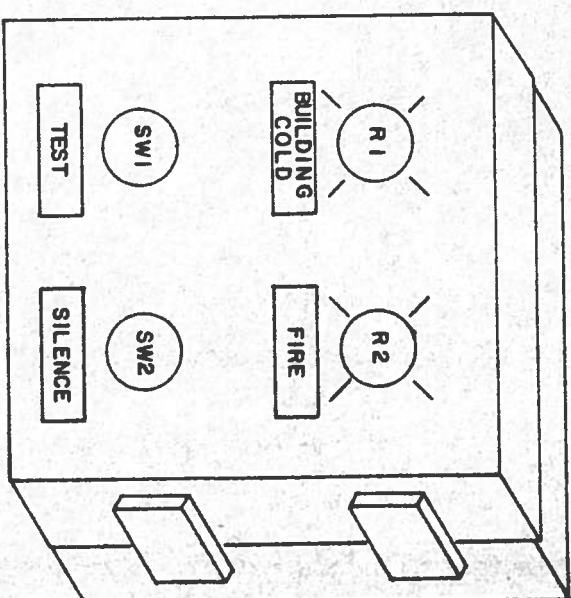

ENCLOSURE LAYOUT

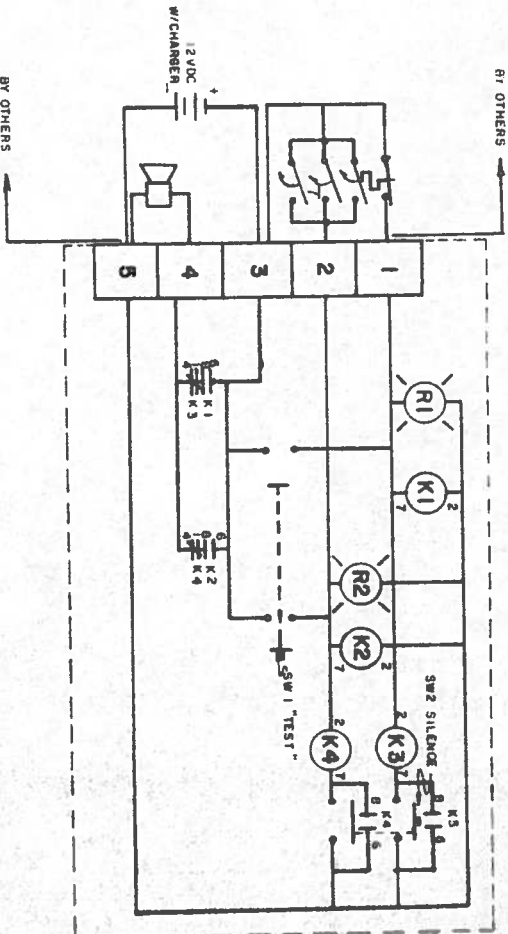

CIRCUIT ALARM

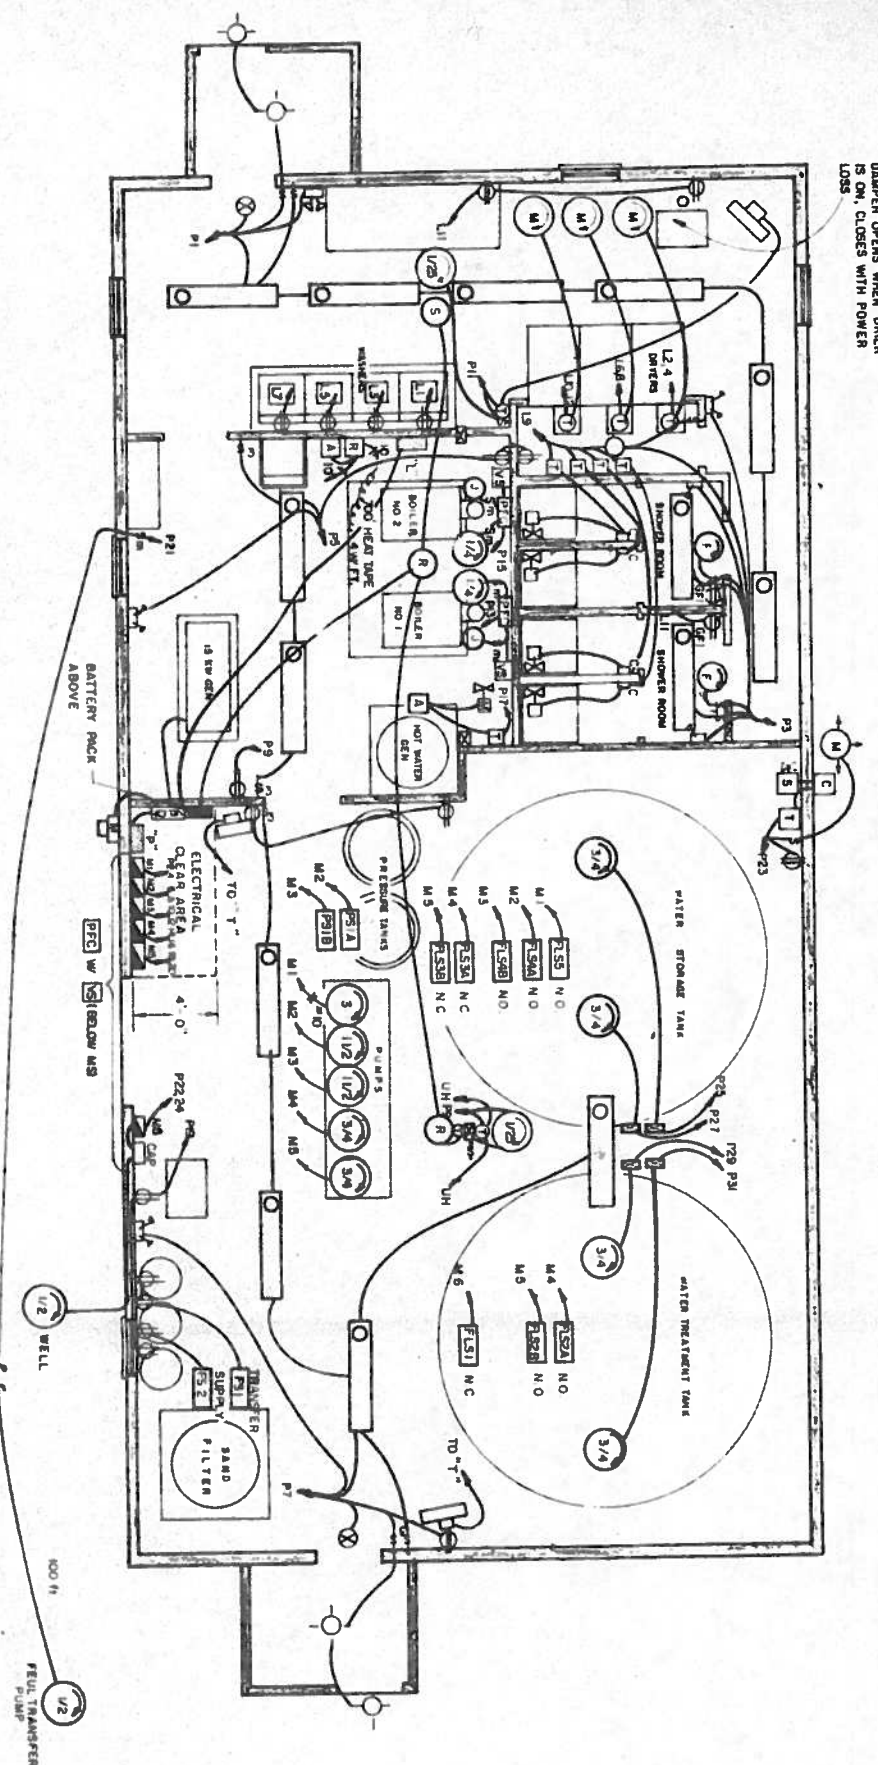

ELECTRICAL PLAN

- LEGEND
- LIGHT INCANDESCENT
 - FIXTURE WALL MOUNTED
 - JUNCTION BOX
 - DUPLX RECEPTACLE
 - FLUORESCENT FIXTURE
 - SINGLE POLE SWITCH
 - 3 WAY SWITCH
 - THERMOSTAT
 - TRANSFORMER
 - CONTROLLER
 - POWER PANEL
 - ALARM PANEL
 - MOTOR STARTER

- METER BASE
- AQUASTAT
- SOLENOID VALVE
- MOTOR & HP
- ALARM HORN
- FLOAT SWITCH
- PRESSURE SWITCH
- FLOW SWITCH
- UNIT HEATER
- HOME RUN TO PANEL
- NUMBER OF WIRES

DATE	REVISIONS	INITIALS

U. S. Department of Health, & Human Services
Public Health Service
Indian Health Service

TULUKSAK, ALASKA
ELECTRICAL PLAN

SHEET NO. 23

PUBLIC LAW 96-121 PROJECT

PROJECT NO. AN - 01-280

TOTAL SHEETS 30

DESIGNED BY

CHECKED BY

DATE

DATE




SAINTANON FACTORY'S CONSTRUCTION BRANCH

ENVIRONMENTAL HEALTH BRANCH

ALASKA NATIVE HEALTH SERVICE

ANCHORAGE, ALASKA








001 Printed on 10/10/80 1/10/80

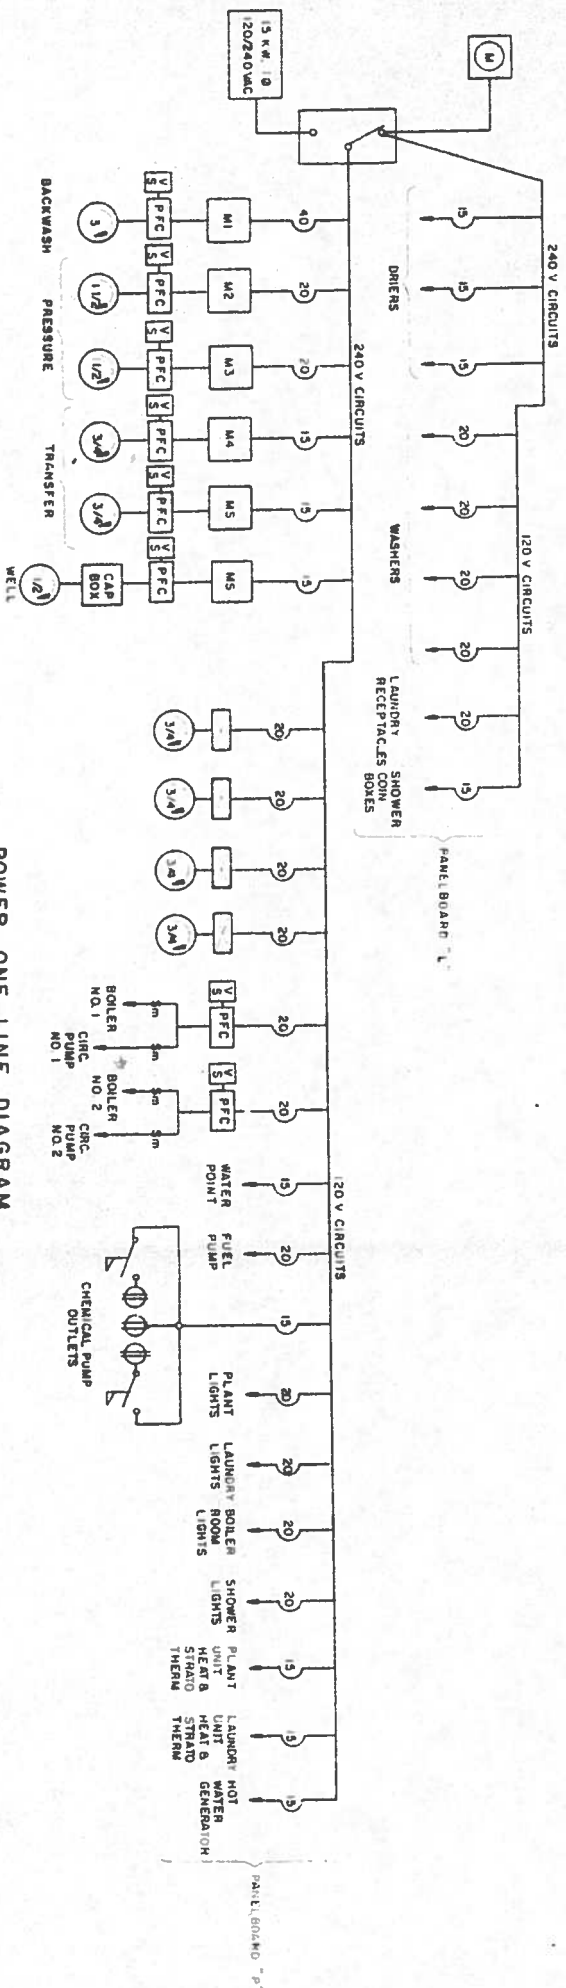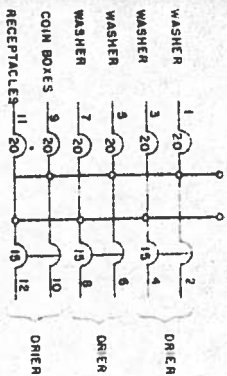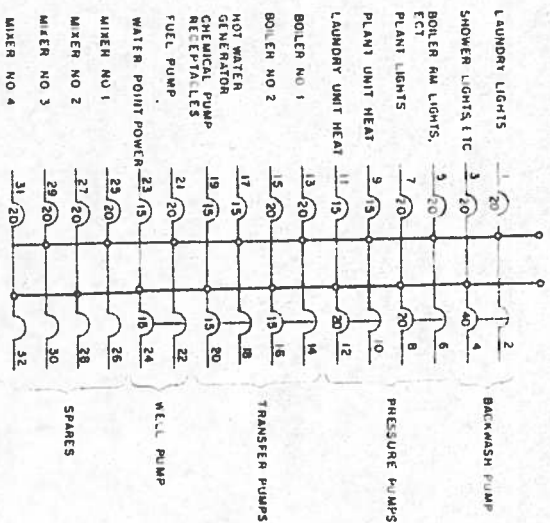

Design Engineer	Checked By
Drawn By	Date
Reviewed By	Date



U. S. Department of Health, Education & Welfare Services Public Health Service Indian Health Service	
TULUKSAK, ALASKA ELECTRICAL PANELBOARDS "P" & "L" POWER ONE LINE DIAGRAM PROJECT NO. AN-81-220	
DRAWN BY: B. KIRSCHBAUM DATE: MAY, 1961	CHECKED BY: _____ DATE: _____
SANITATION FACTORY CONSTRUCTION BRANCH ENVIRONMENTAL HEALTH BRANCH ALASKA AREA HEALTH SERVICE ANCHORAGE, ALASKA	SHEET NO. 24 OF 30 TOTAL SHEETS: 30

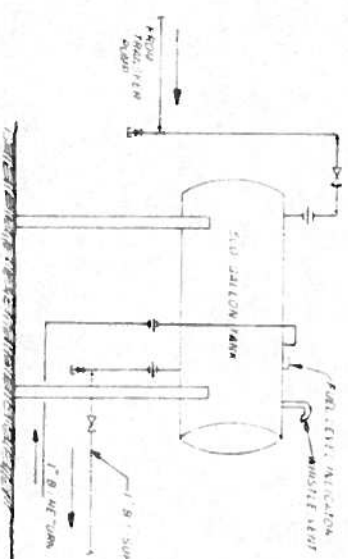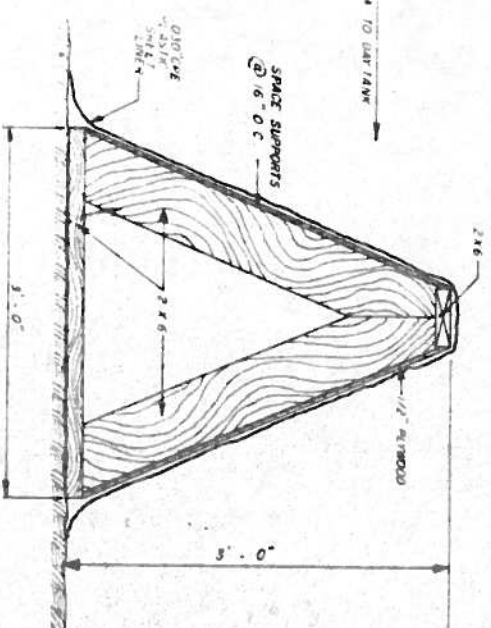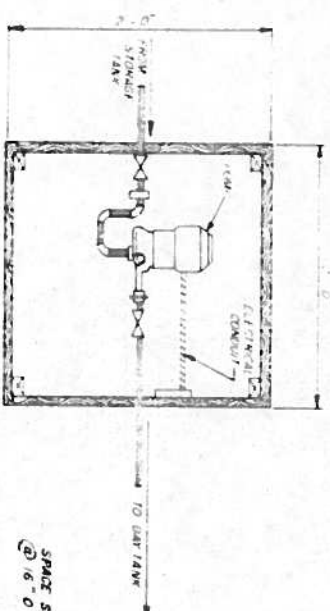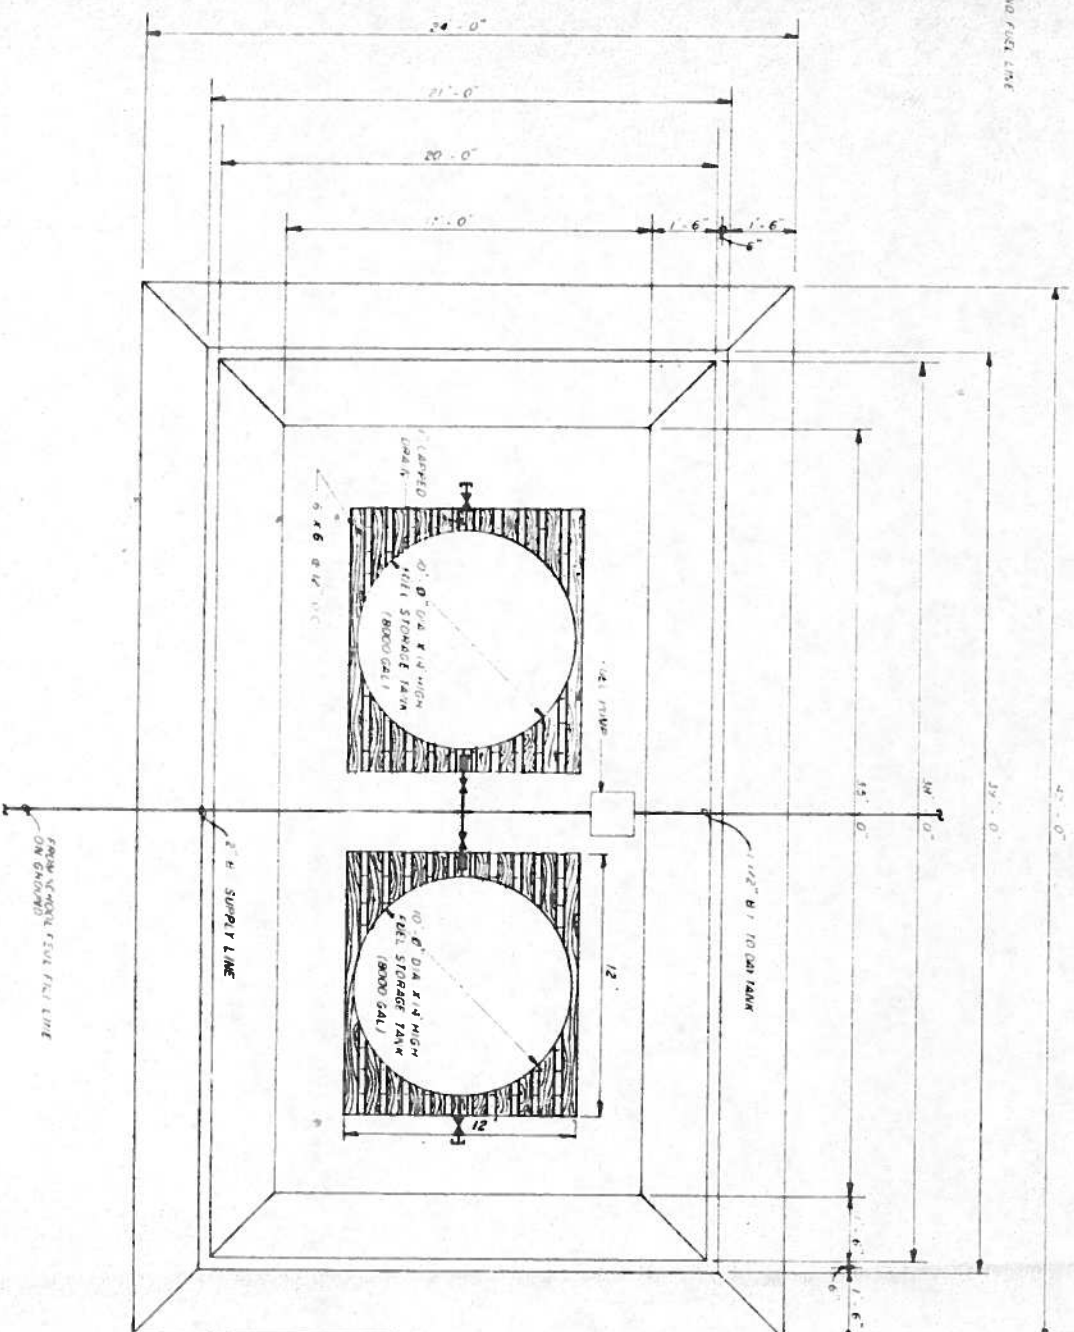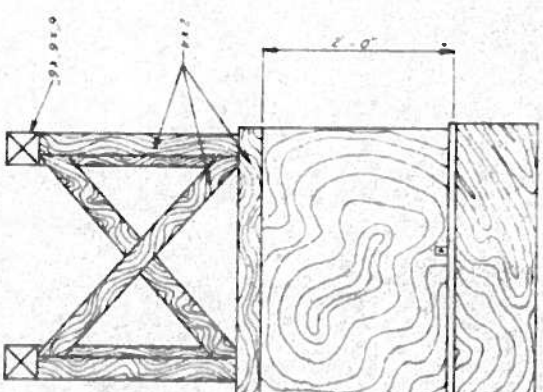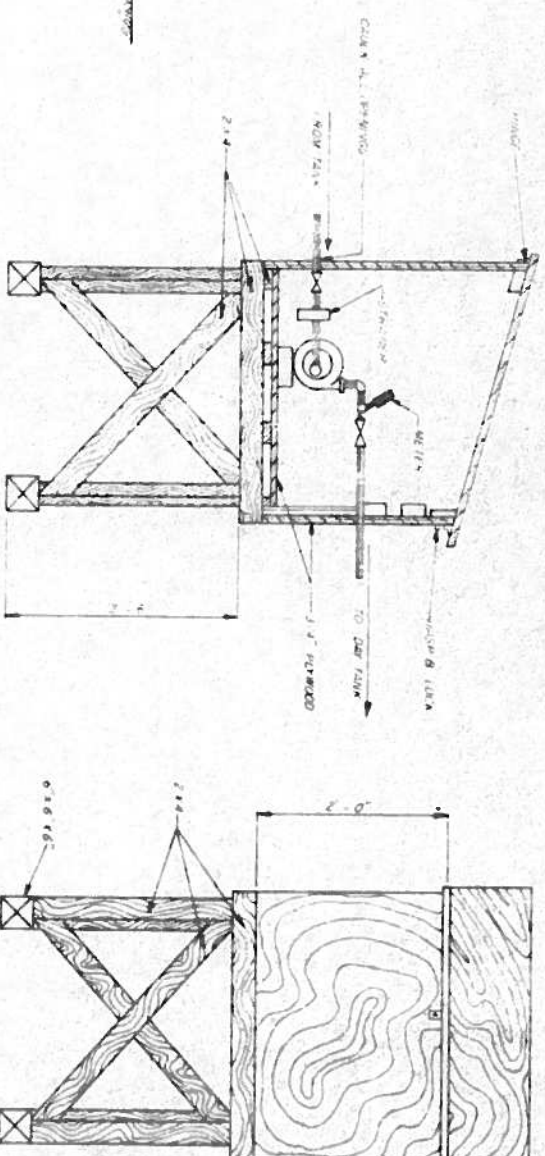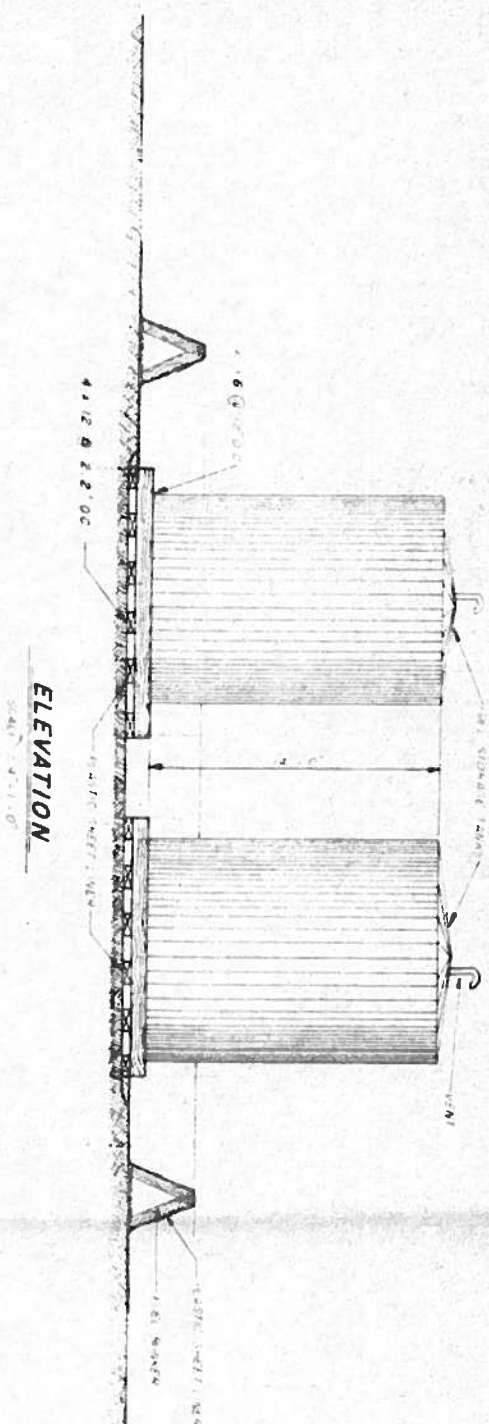[illegible]

U. S. Department of Health, Education & Welfare
Public Health Service
Indian Health Service

TULUKSAK, ALASKA

WATER TREATMENT PLANT
FUEL STORAGE

PUBLIC LAW 84-121 PROJECT

PROJECT NO. AN-81-P20

SEE - 08-01-0000

DRAWN BY **LOWDERMILK**
CHIEF

DATE	1 - 80	DATE
------	--------	------




SANITATION FACILITIES CONSTRUCTION

ENVIRONMENTAL HEALTH

MEMBER AREA NORTH HAVEN
ALBION, ALABAMA

100

001 CHINESE POSTAL SERVICE 1010-7000

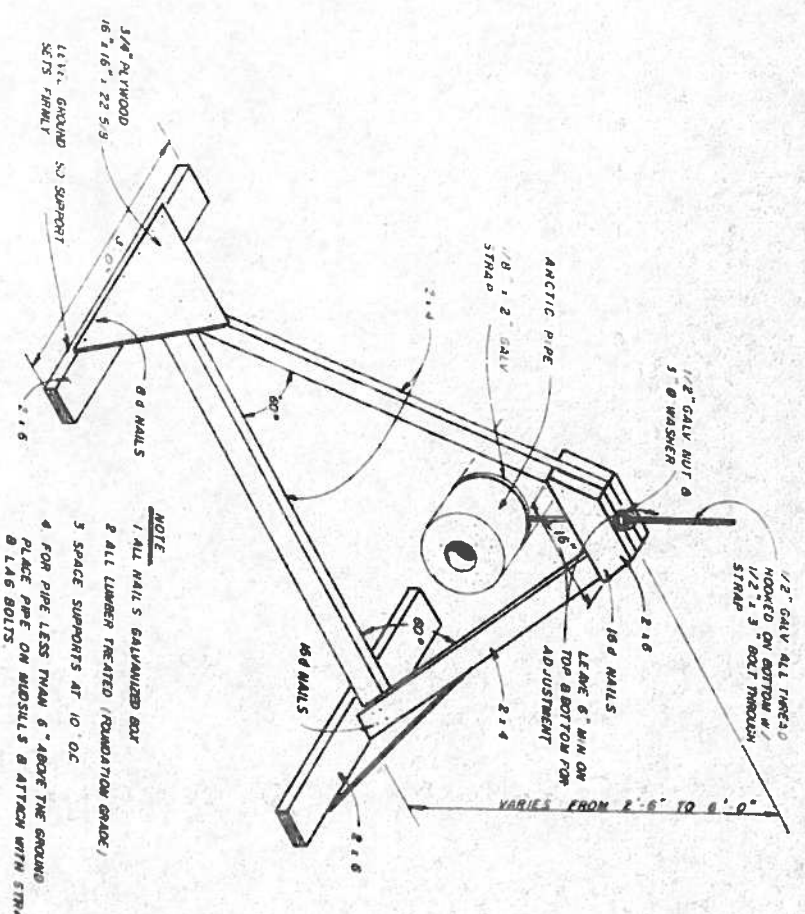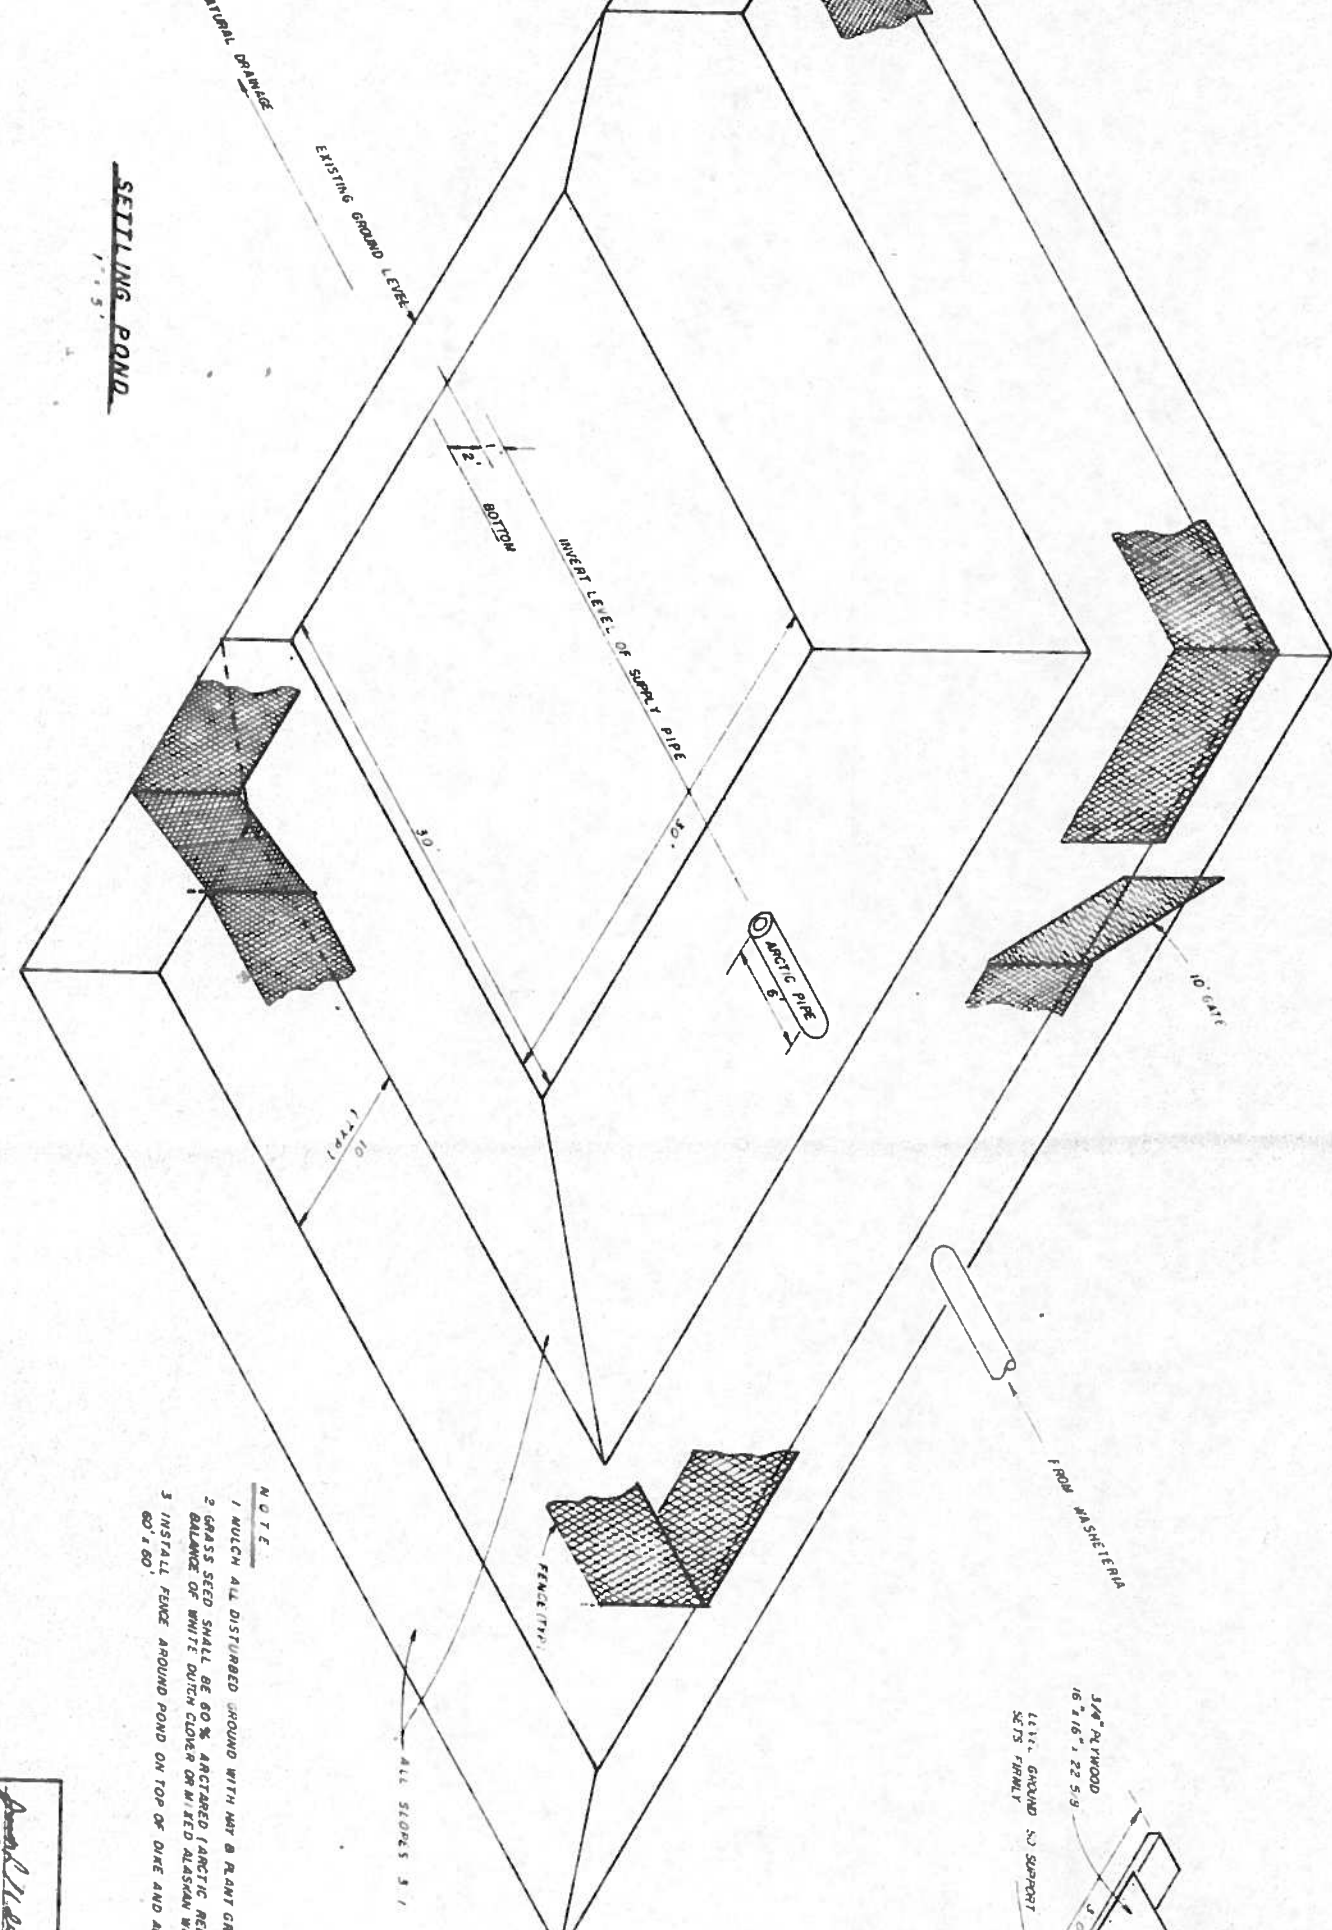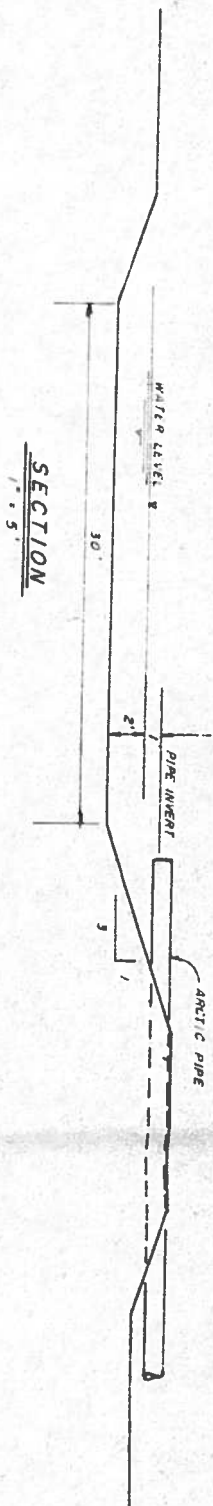


NOTE

- 1 MULCH ALL DISTURBED GROUND WITH NAT. PLANT GRASS
- 2 GRASS SEED SHALL BE 80% ANCHORED (ARCTIC RED RESQUE) WITH A BALANCE OF WHITE DUTCH CLOVER OR MIXED ALASKAN WILDOVER
- 3 INSTALL FENCE AROUND POND ON TOP OF DIKE AND ACROSS THE OPEN END, 60' ± 60'

Drawn by: *[Signature]*
 Checked by: *[Signature]*
 Date: 4-27-81


DATE	REVISIONS	INITIALS

U. S. Department of Health & Human Services Public Health Service Indian Health Service		SHEET NO. 26 OF 30 TOTAL SHEETS
TULUKSAK, ALASKA WASTE WATER DISPOSAL PLAN PUBLIC LAW 96-121 PROJECT PROJECT NO. AN-81-220		
DESIGNED BY: DRF DATE: 4-27-81	CHECKED BY: <i>[Signature]</i> DATE:	
SANITATION FACILITIES CONSTRUCTION BRANCH ENVIRONMENTAL HEALTH BRANCH ALASKA AREA, NATIVE HEALTH SERVICE ANCHORAGE, ALASKA		

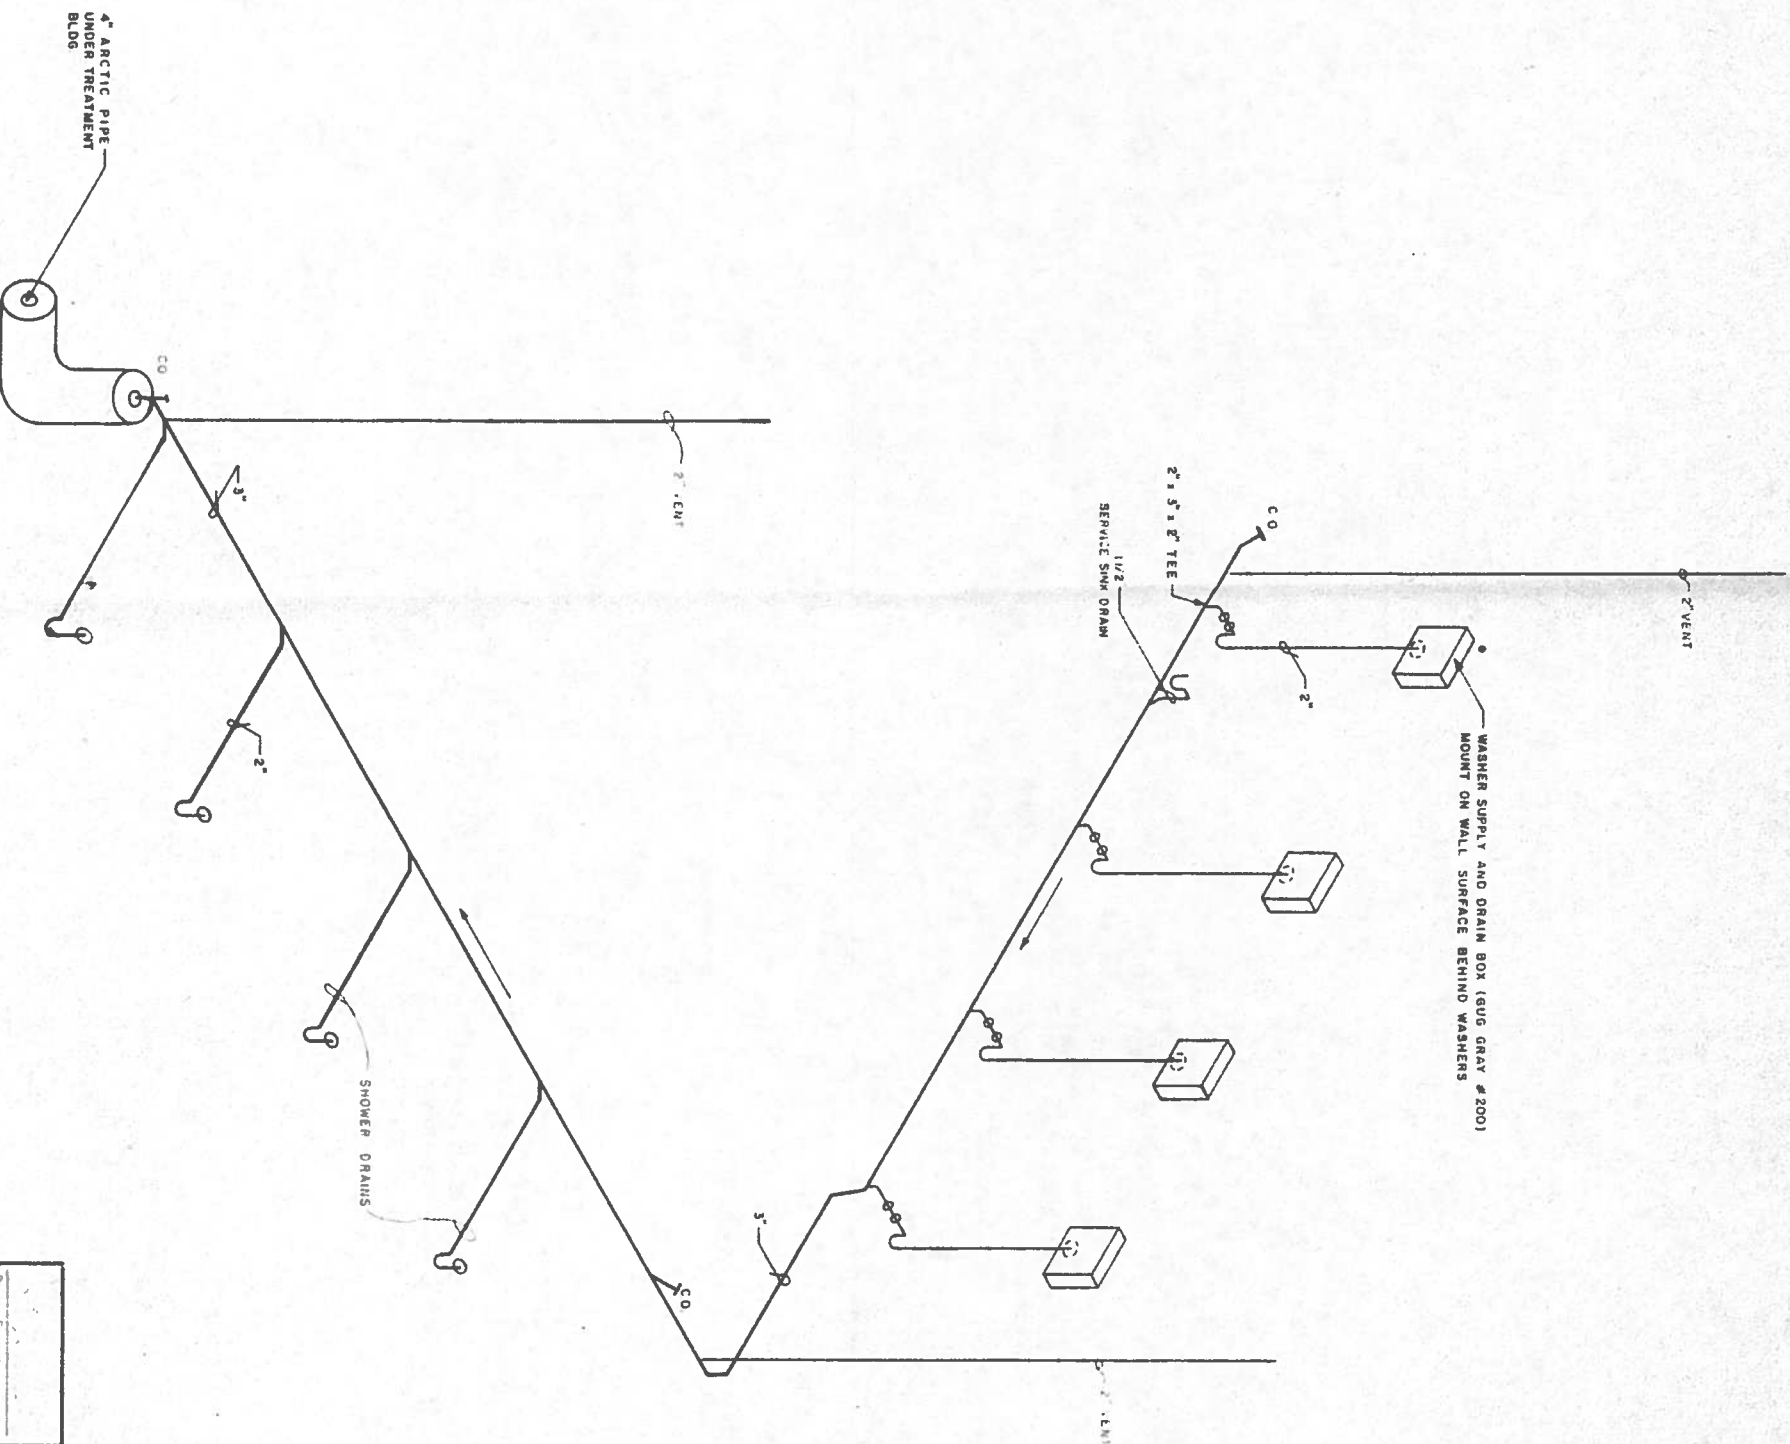


Design Engineer	
Check Engineer	
Waste Water	
Waste Water	


DATE	REVISIONS	INITIALS
U. S. Department of Health, & Human Services		
Public Health Service		
Indian Health Service		
TULUKSAK, ALASKA		
WASTE WATER PLUMBING		SHEET NO. 27
PUBLIC LAW 96-121 PROJECT		OF 30
PROJECT NO. AN-81-220		TOTAL SHEETS
DRAWN BY	CHECKED BY	
WNT	WNT	
DATE	DATE	
JUNE, 1981		
SANITATION FACILITIES CONSTRUCTION BRANCH		
ENVIRONMENTAL HEALTH BRANCH		
ALASKA AREA NATIVE HEALTH SERVICES		
ANCHORAGE, ALASKA		

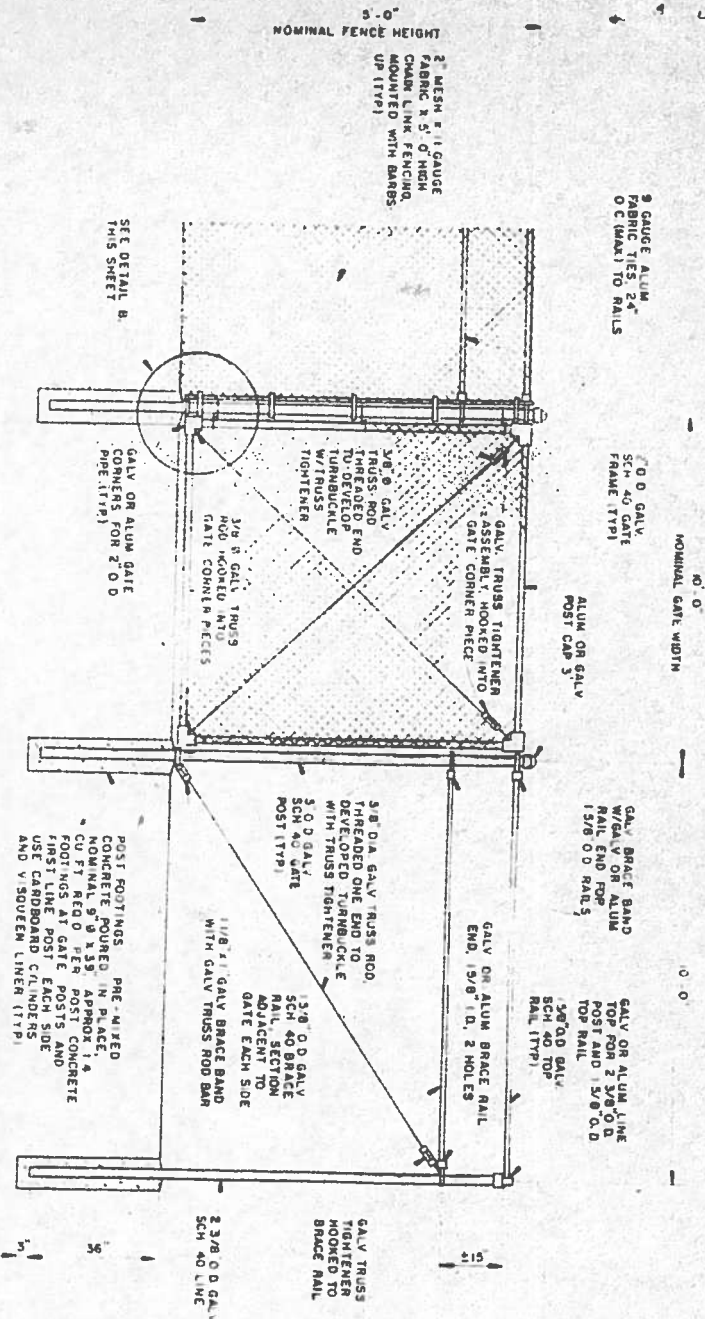


GATE INSTALLATION DETAIL
NTS

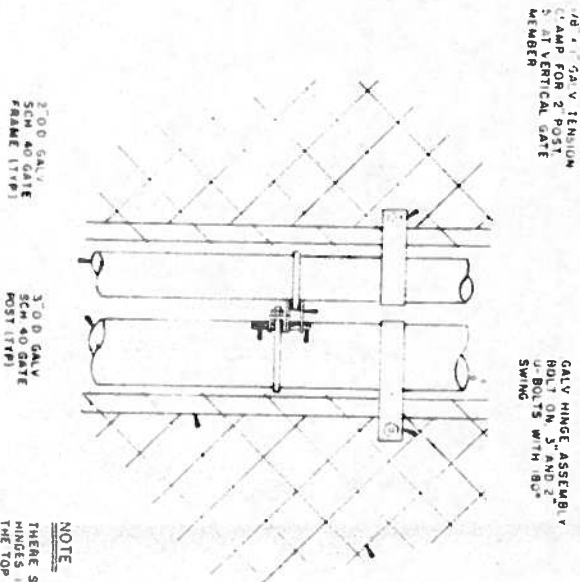

NOTE
THESE SHALL BE THREE (3)
HINGES INSTALLED PER GATE
INSTALLATION. TWO (2) SHALL BE
SUPPORTING GATE AND ONE (1)
OF HINGE ON TOP. THE LOWEST
HINGE SHALL BE INSTALLED
TO PREVENT SWING ON BOTTOM
MOVEMENT OF GATES.

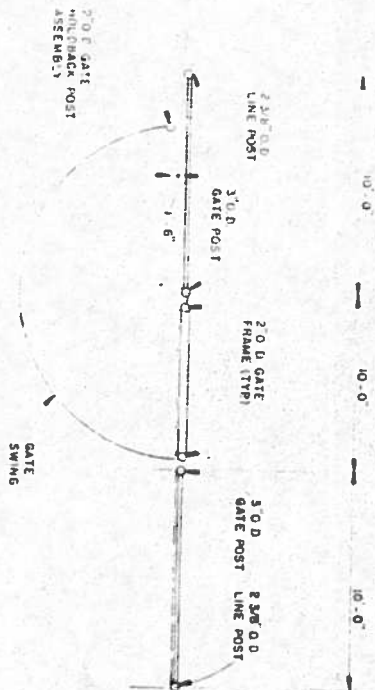

POST LOCATIONS IN GATE VICINITY
NTS

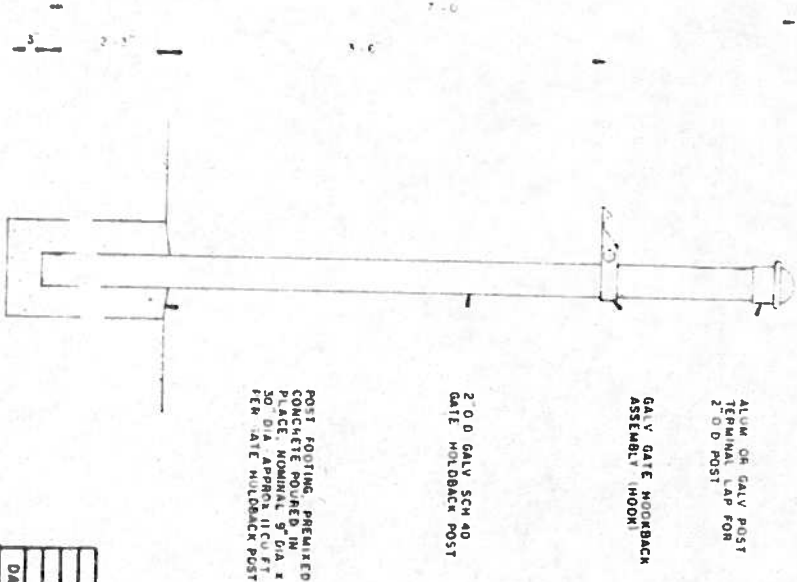

NOTES
1. SEE DETAIL, THIS SHEET FOR
LOCATION OF GATE HOLDBACK
POSTS
2. ACTUAL ELEVATION OF GATE
HOLDBACK ASSEMBLY MUST
TO BE DETERMINED IN FIELD
AS DETERMINED BY ELEVATION
OF GATE HOLDBACK LATCH
ON GATE

REVISIONS		INITIALS	
DATE			

U. S. Department of Health & Human Services
Public Health Service
Indian Health Service

TULUKSAK, ALASKA



CHAIN LINK FENCE GATE DETAILS
PUBLIC LAW 96-121 PROJECT
PROJECT NO. AN-81-200

DRAWN BY: *John A. Hille*
DATE: OCTOBER, 1980

CHECKED BY: *John A. Hille*
DATE:

SANITATION FACILITIES CONSTRUCTION BRANCH
ENVIRONMENTAL HEALTH BRANCH
ALASKA INDIAN HEALTH SERVICE

SHEET NO. 28
OF 30
TOTAL SHEETS

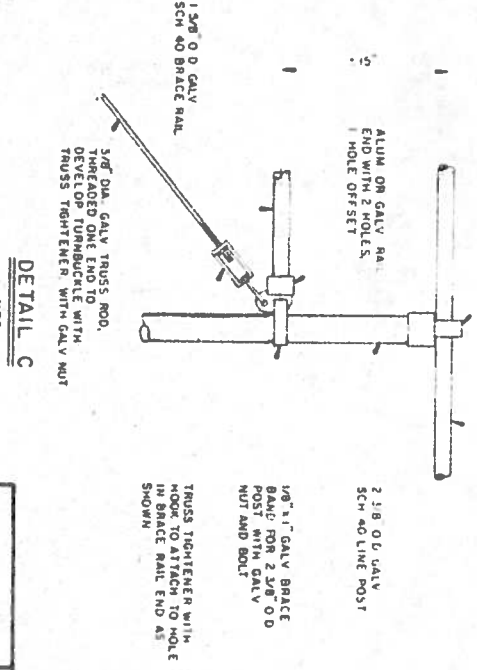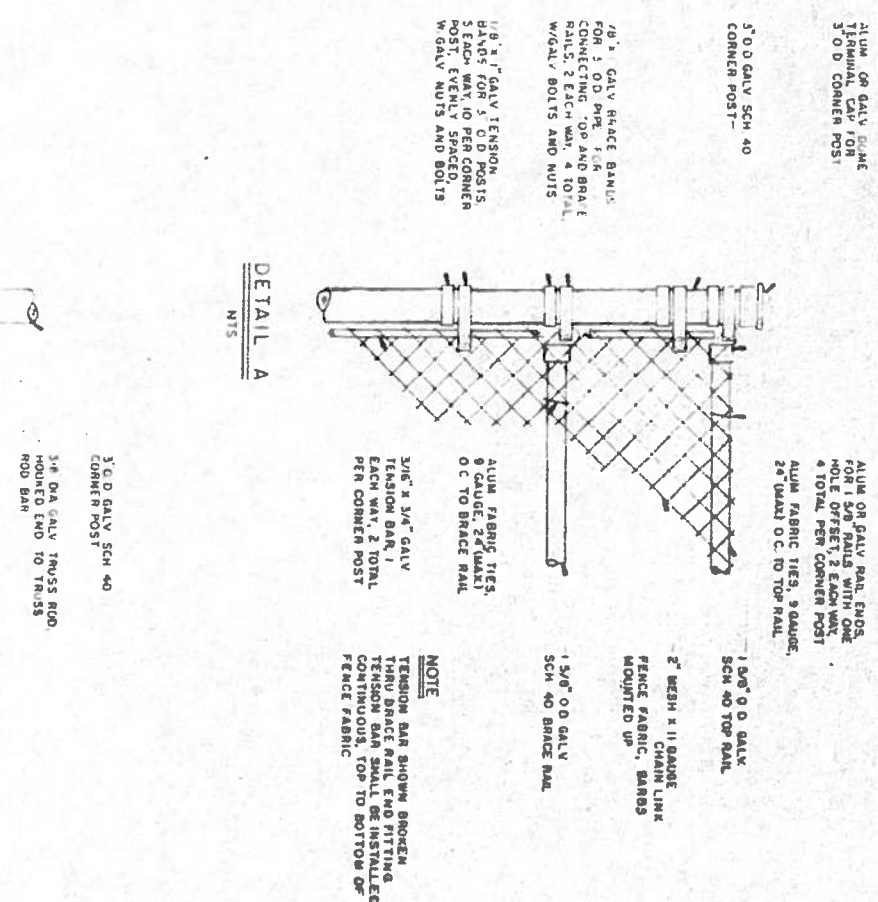[illegible]

U. S. Department of Health, & Human Services
Public Health Service
Indian Health Service

TULUKSAK, ALASKA
CHAIN LINK FENCE

CHAIN LINK FENCE
CORNER AND LINE POST DETAILS
PUBLIC LAW 86-121 PROJECT

DRAWN BY **D KIRSCHBAUM**
 DATE **OCTOBER, 1980**
 CHECKED BY
 DATE

SANITATION FACILITIES CONSTRUCTION BRANCH
ENVIRONMENTAL HEALTH BRANCH
ALASKA DELTA MATTER HEALTH SERVICE
ANCHORAGE, ALASKA

