


User: JWANDER Mar 17, 2021 - 1:22pm
Drawing: K:\JBS\32190078 KONGIGANAK VSW\ACAD-DESIGN\DR PHASE II\32190078_KONG_C-301_SITE PLAN.DWG - Layout: C-301
Xrefs: BR2234REV.DWG KONGIGANAK_NAD_B3.DWG KONGIGANAK_100.DWG - Images: KONG_1FT.TIF KONG_2FT.TIF

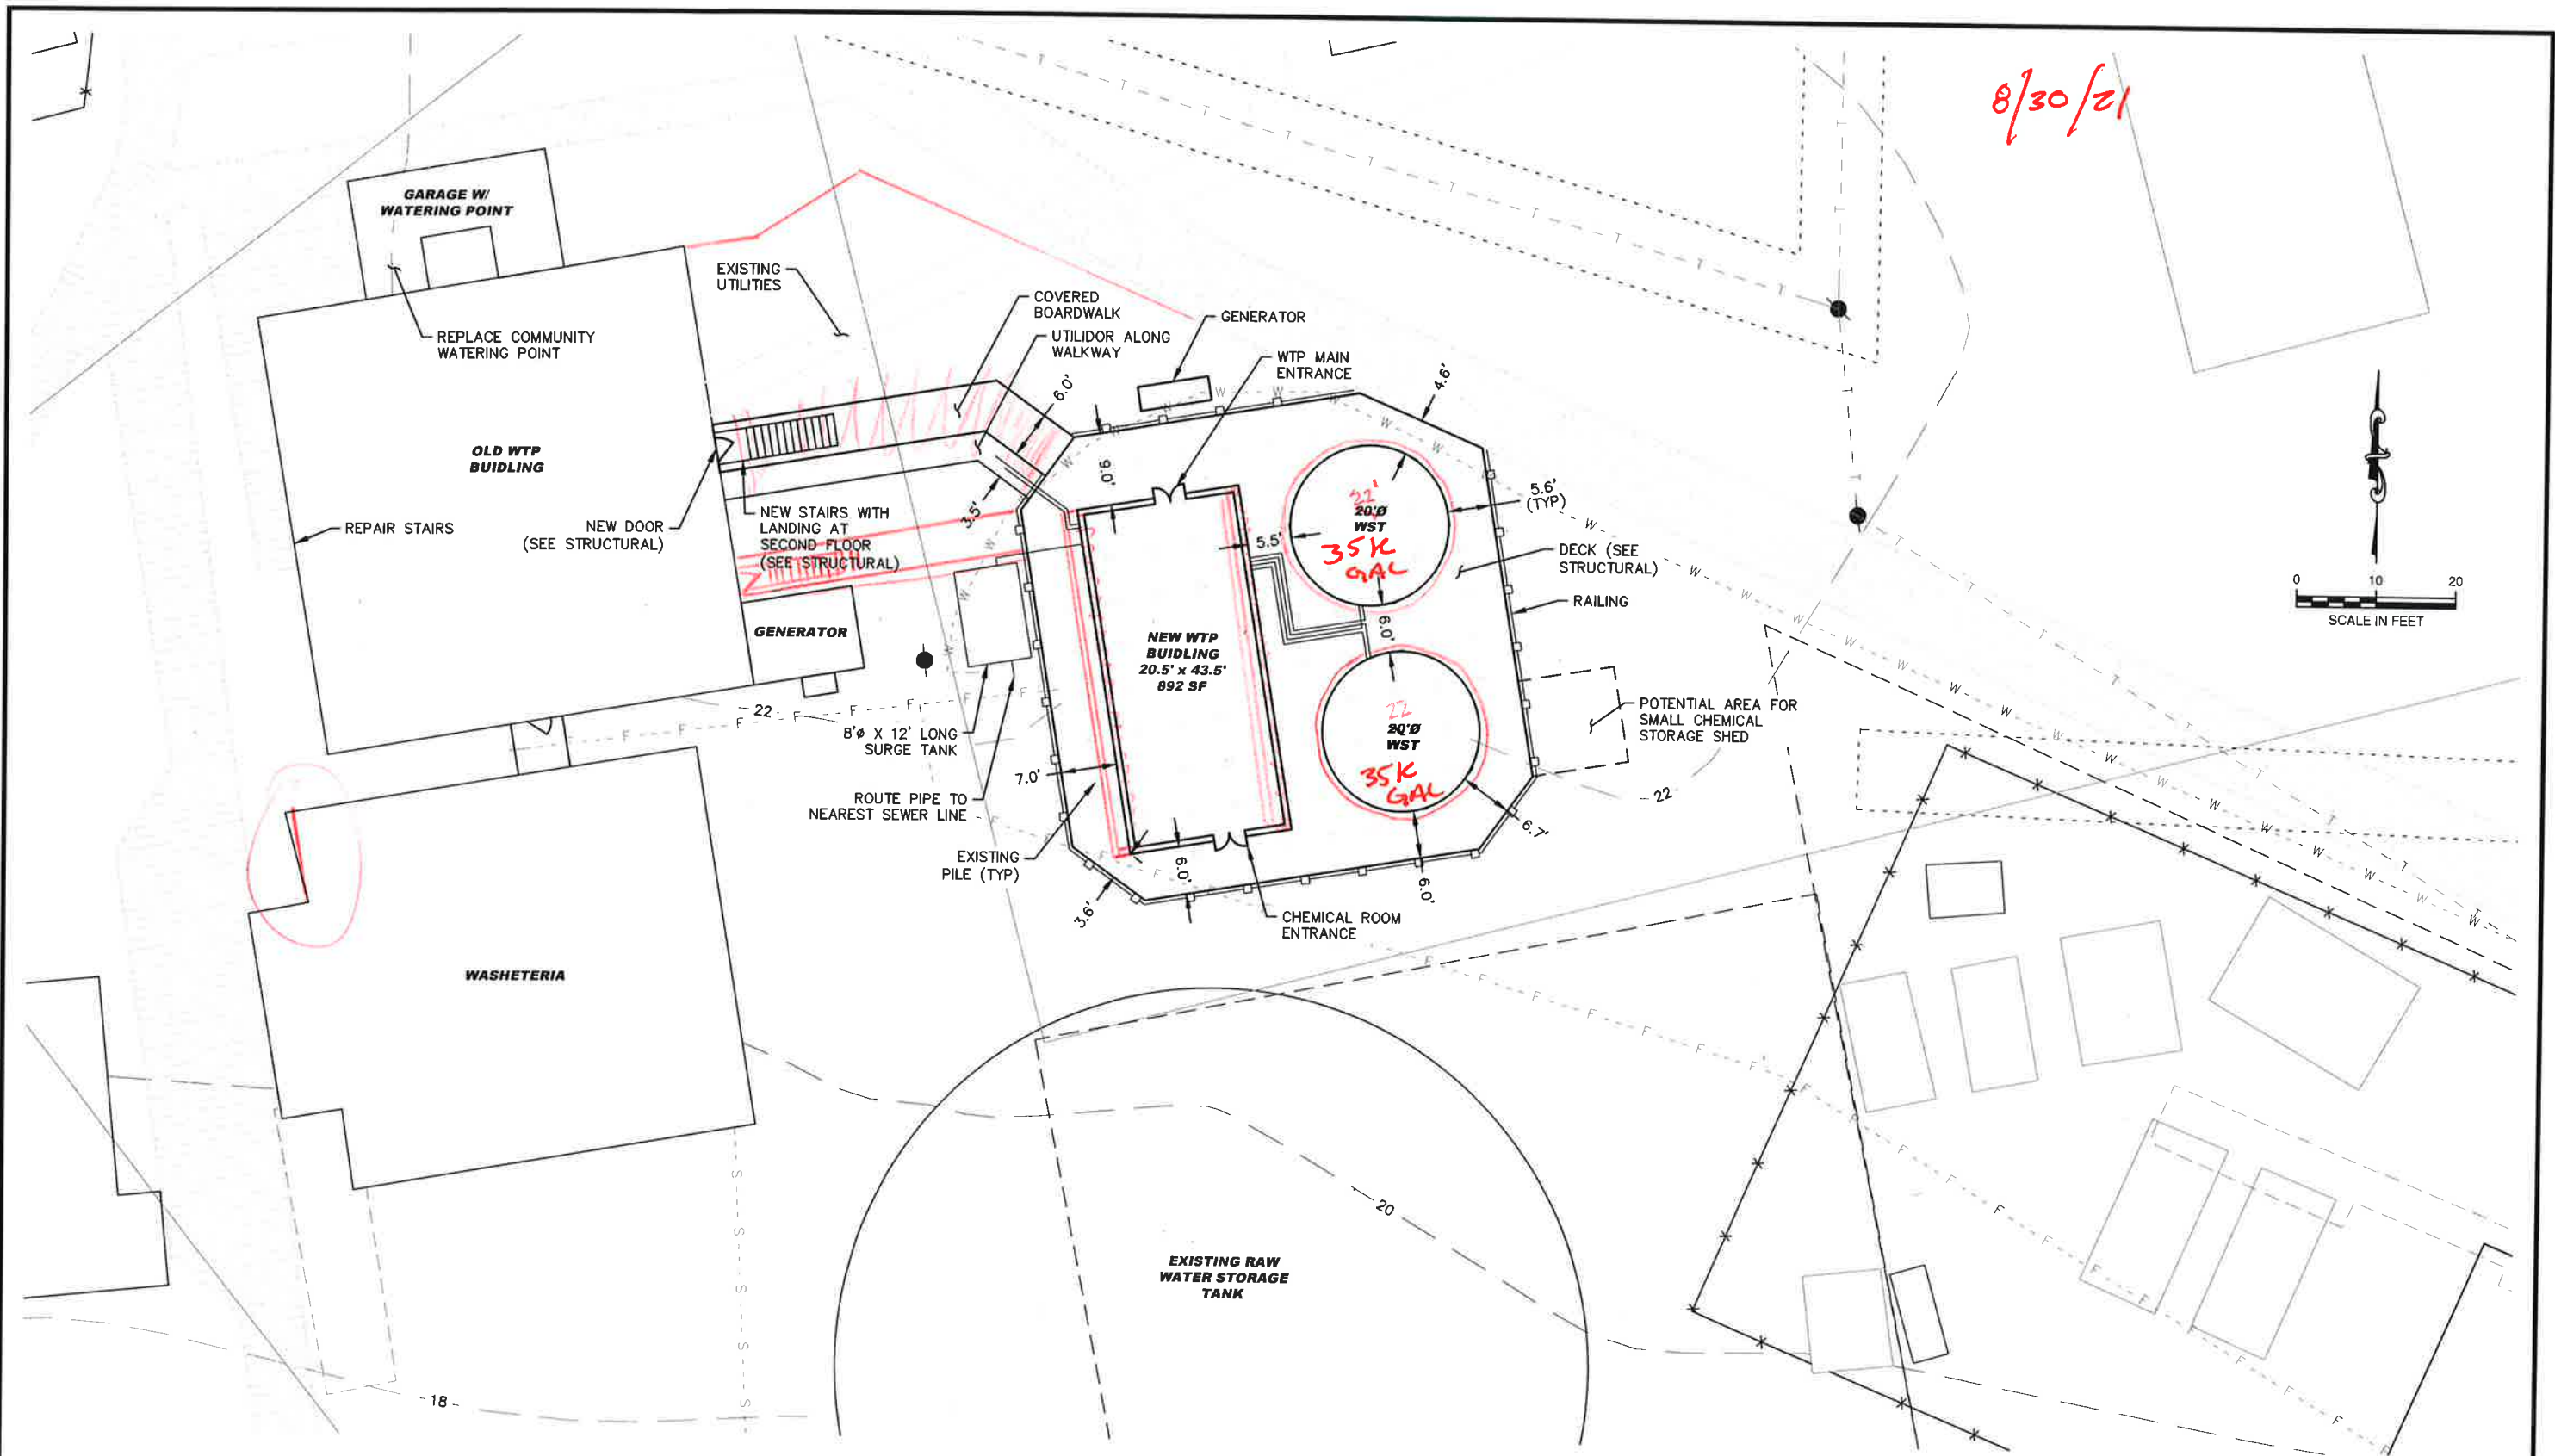

8/30/21

REVISIONS				REVISIONS			
NO.	DATE	BY	DESCRIPTION	NO.	DATE	BY	DESCRIPTION

Project No. 32190078
AEC No. 697

Bristol
ENGINEERING
SERVICES COMPANY, LLC
Phone (907) 563-0013 Fax (907) 563-6713

VILLAGE SAFE WATER



NOT FOR
CONSTRUCTION

35% PRELIMINARY DESIGN						SHEET NO.	
KONGIGANAK WATER TREATMENT PLANT KONGIGANAK, ALASKA						C-301	
SITE PLAN						SHEET X OF X	
SCALE: SHOWN	DESIGNED: JDW	CHECKED: VBW	DRAWN: JDW	DATE: MAR 2021			